


**NOT FOR CONSTRUCTION,
FOR COORDINATION ONLY**


NO DRAWINGS DISPLAYING DATE OF ISSUANCE ON OR PRIOR TO
THAT SHOWN HERE ARE APPROVED FOR CONSTRUCTION

A1.0

803 LINCOLN WAY WEST SOUTH BEND, IN 46616
PHONE (574) 289 1066 FAX (574) 289-4550

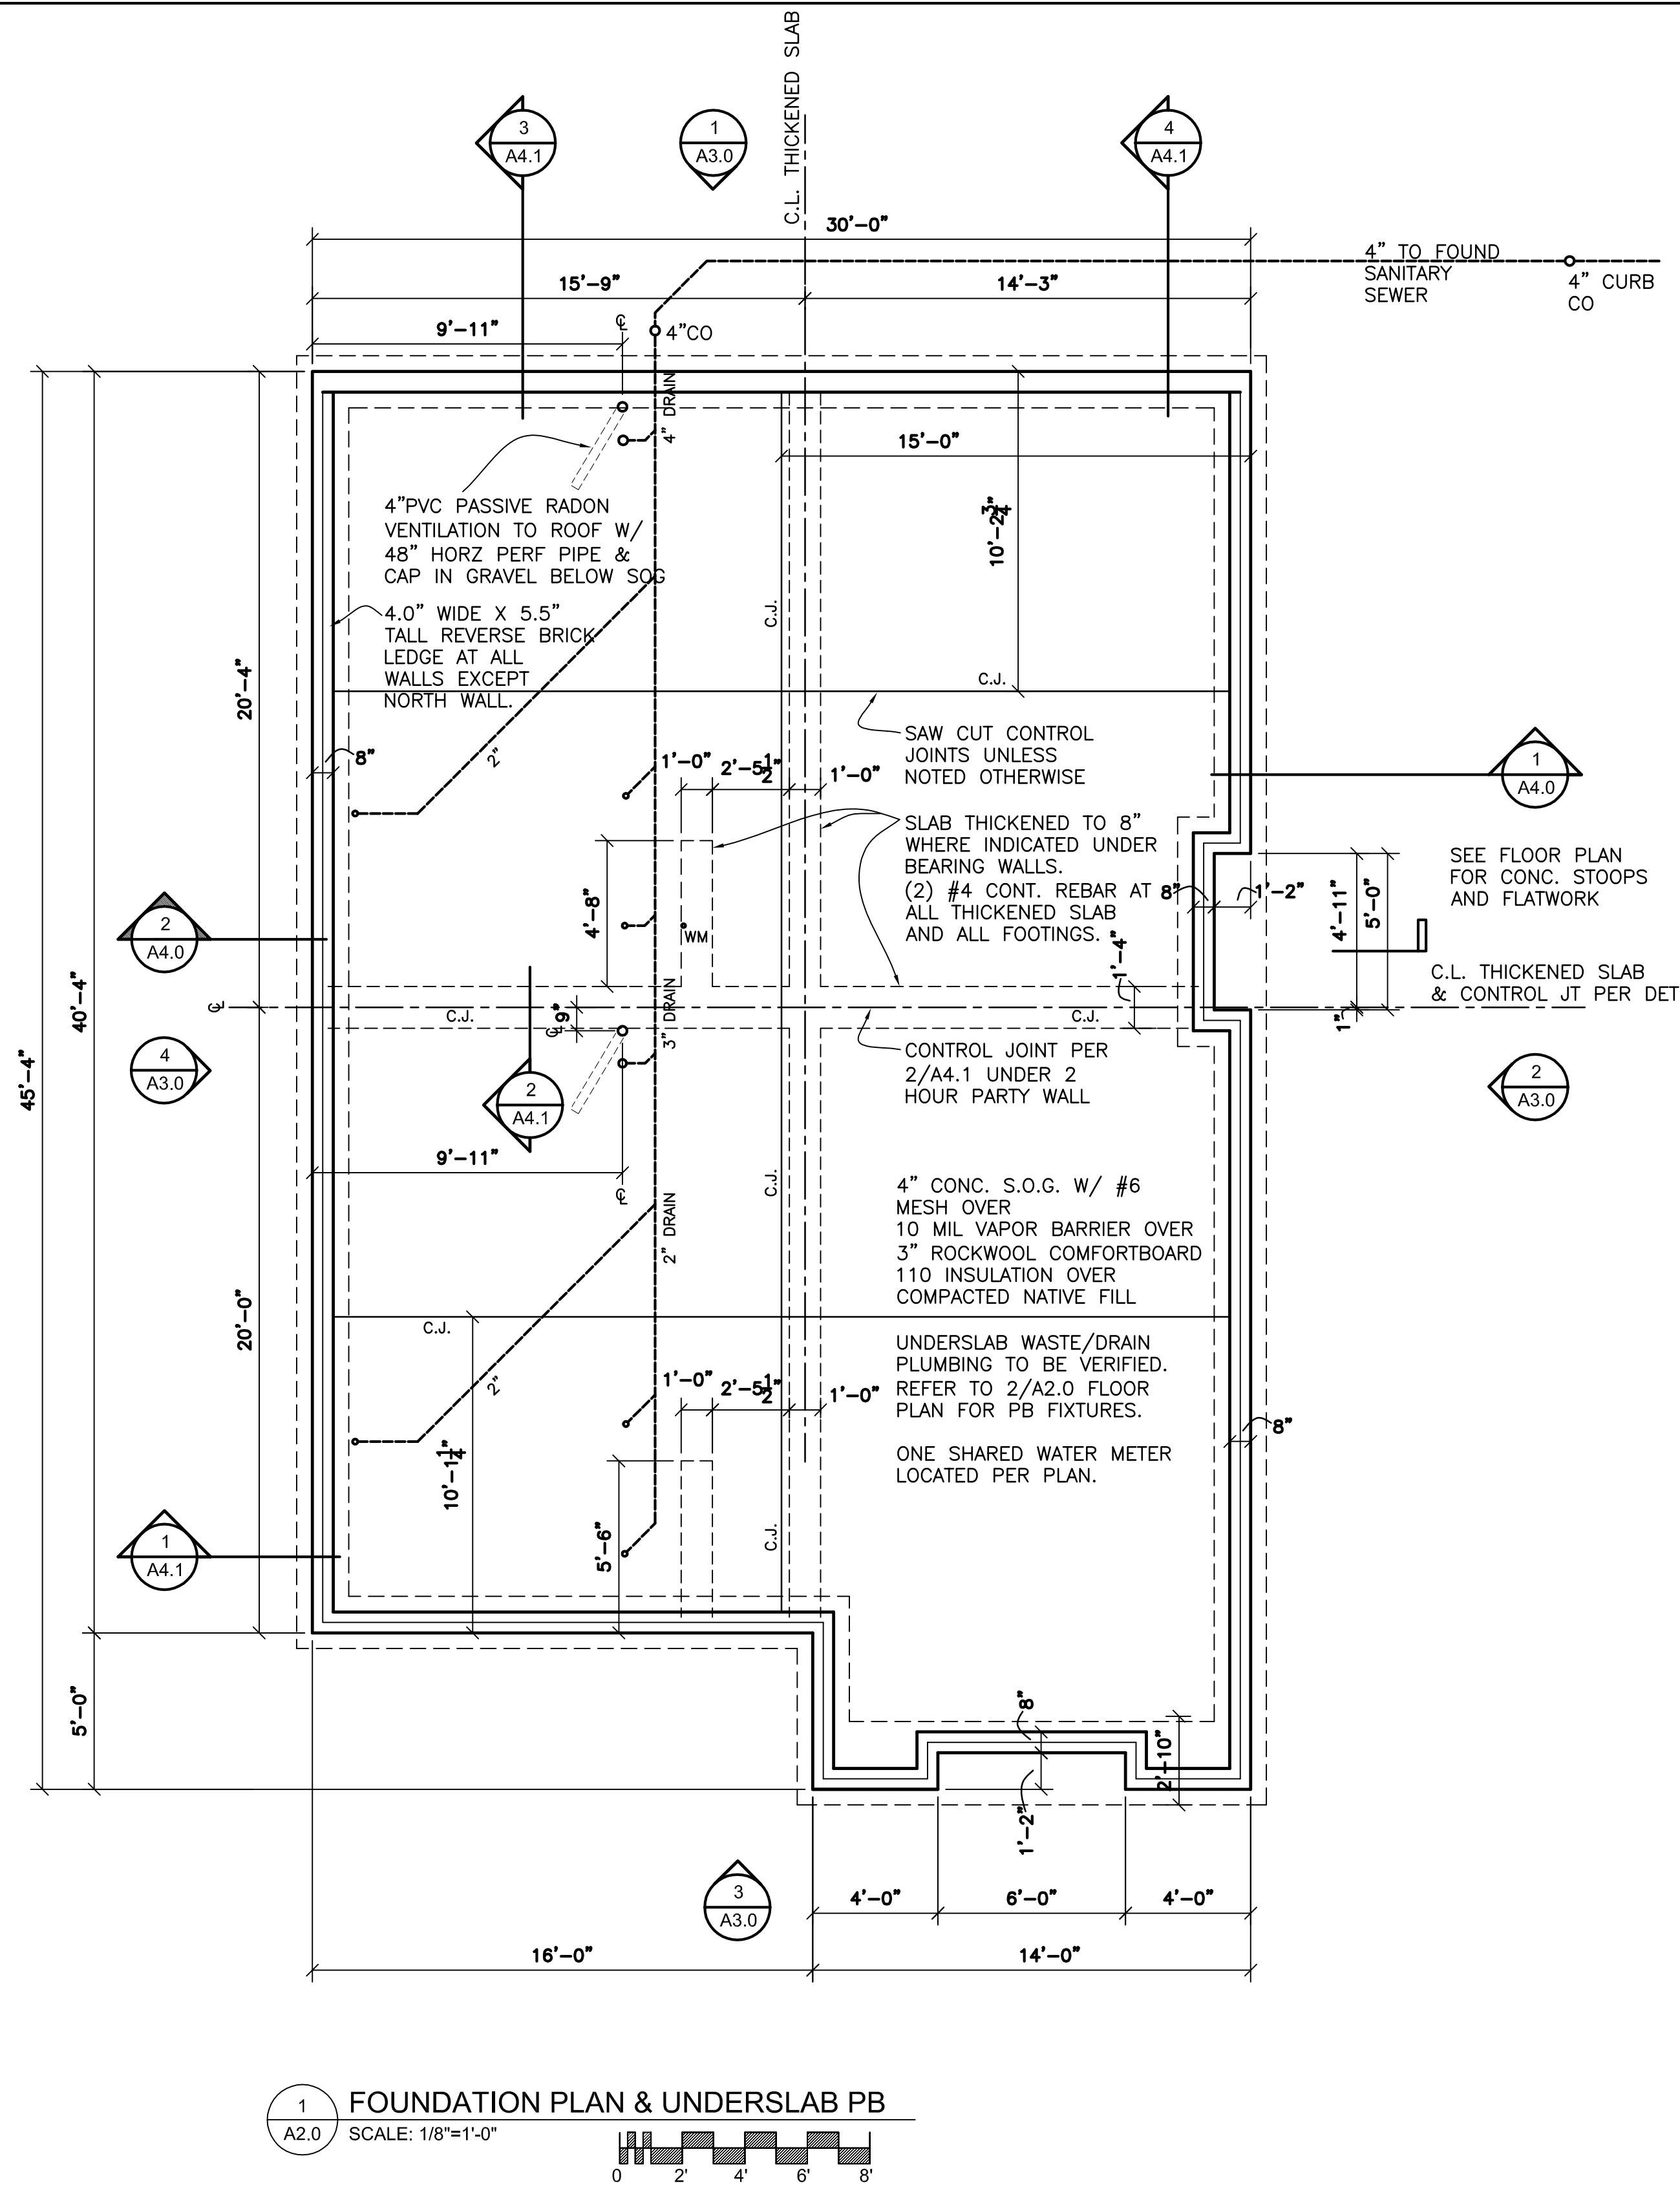

1 FOUNDATION PLAN & UNDERSLAB PB
SCALE: 1/8"=1'-0"

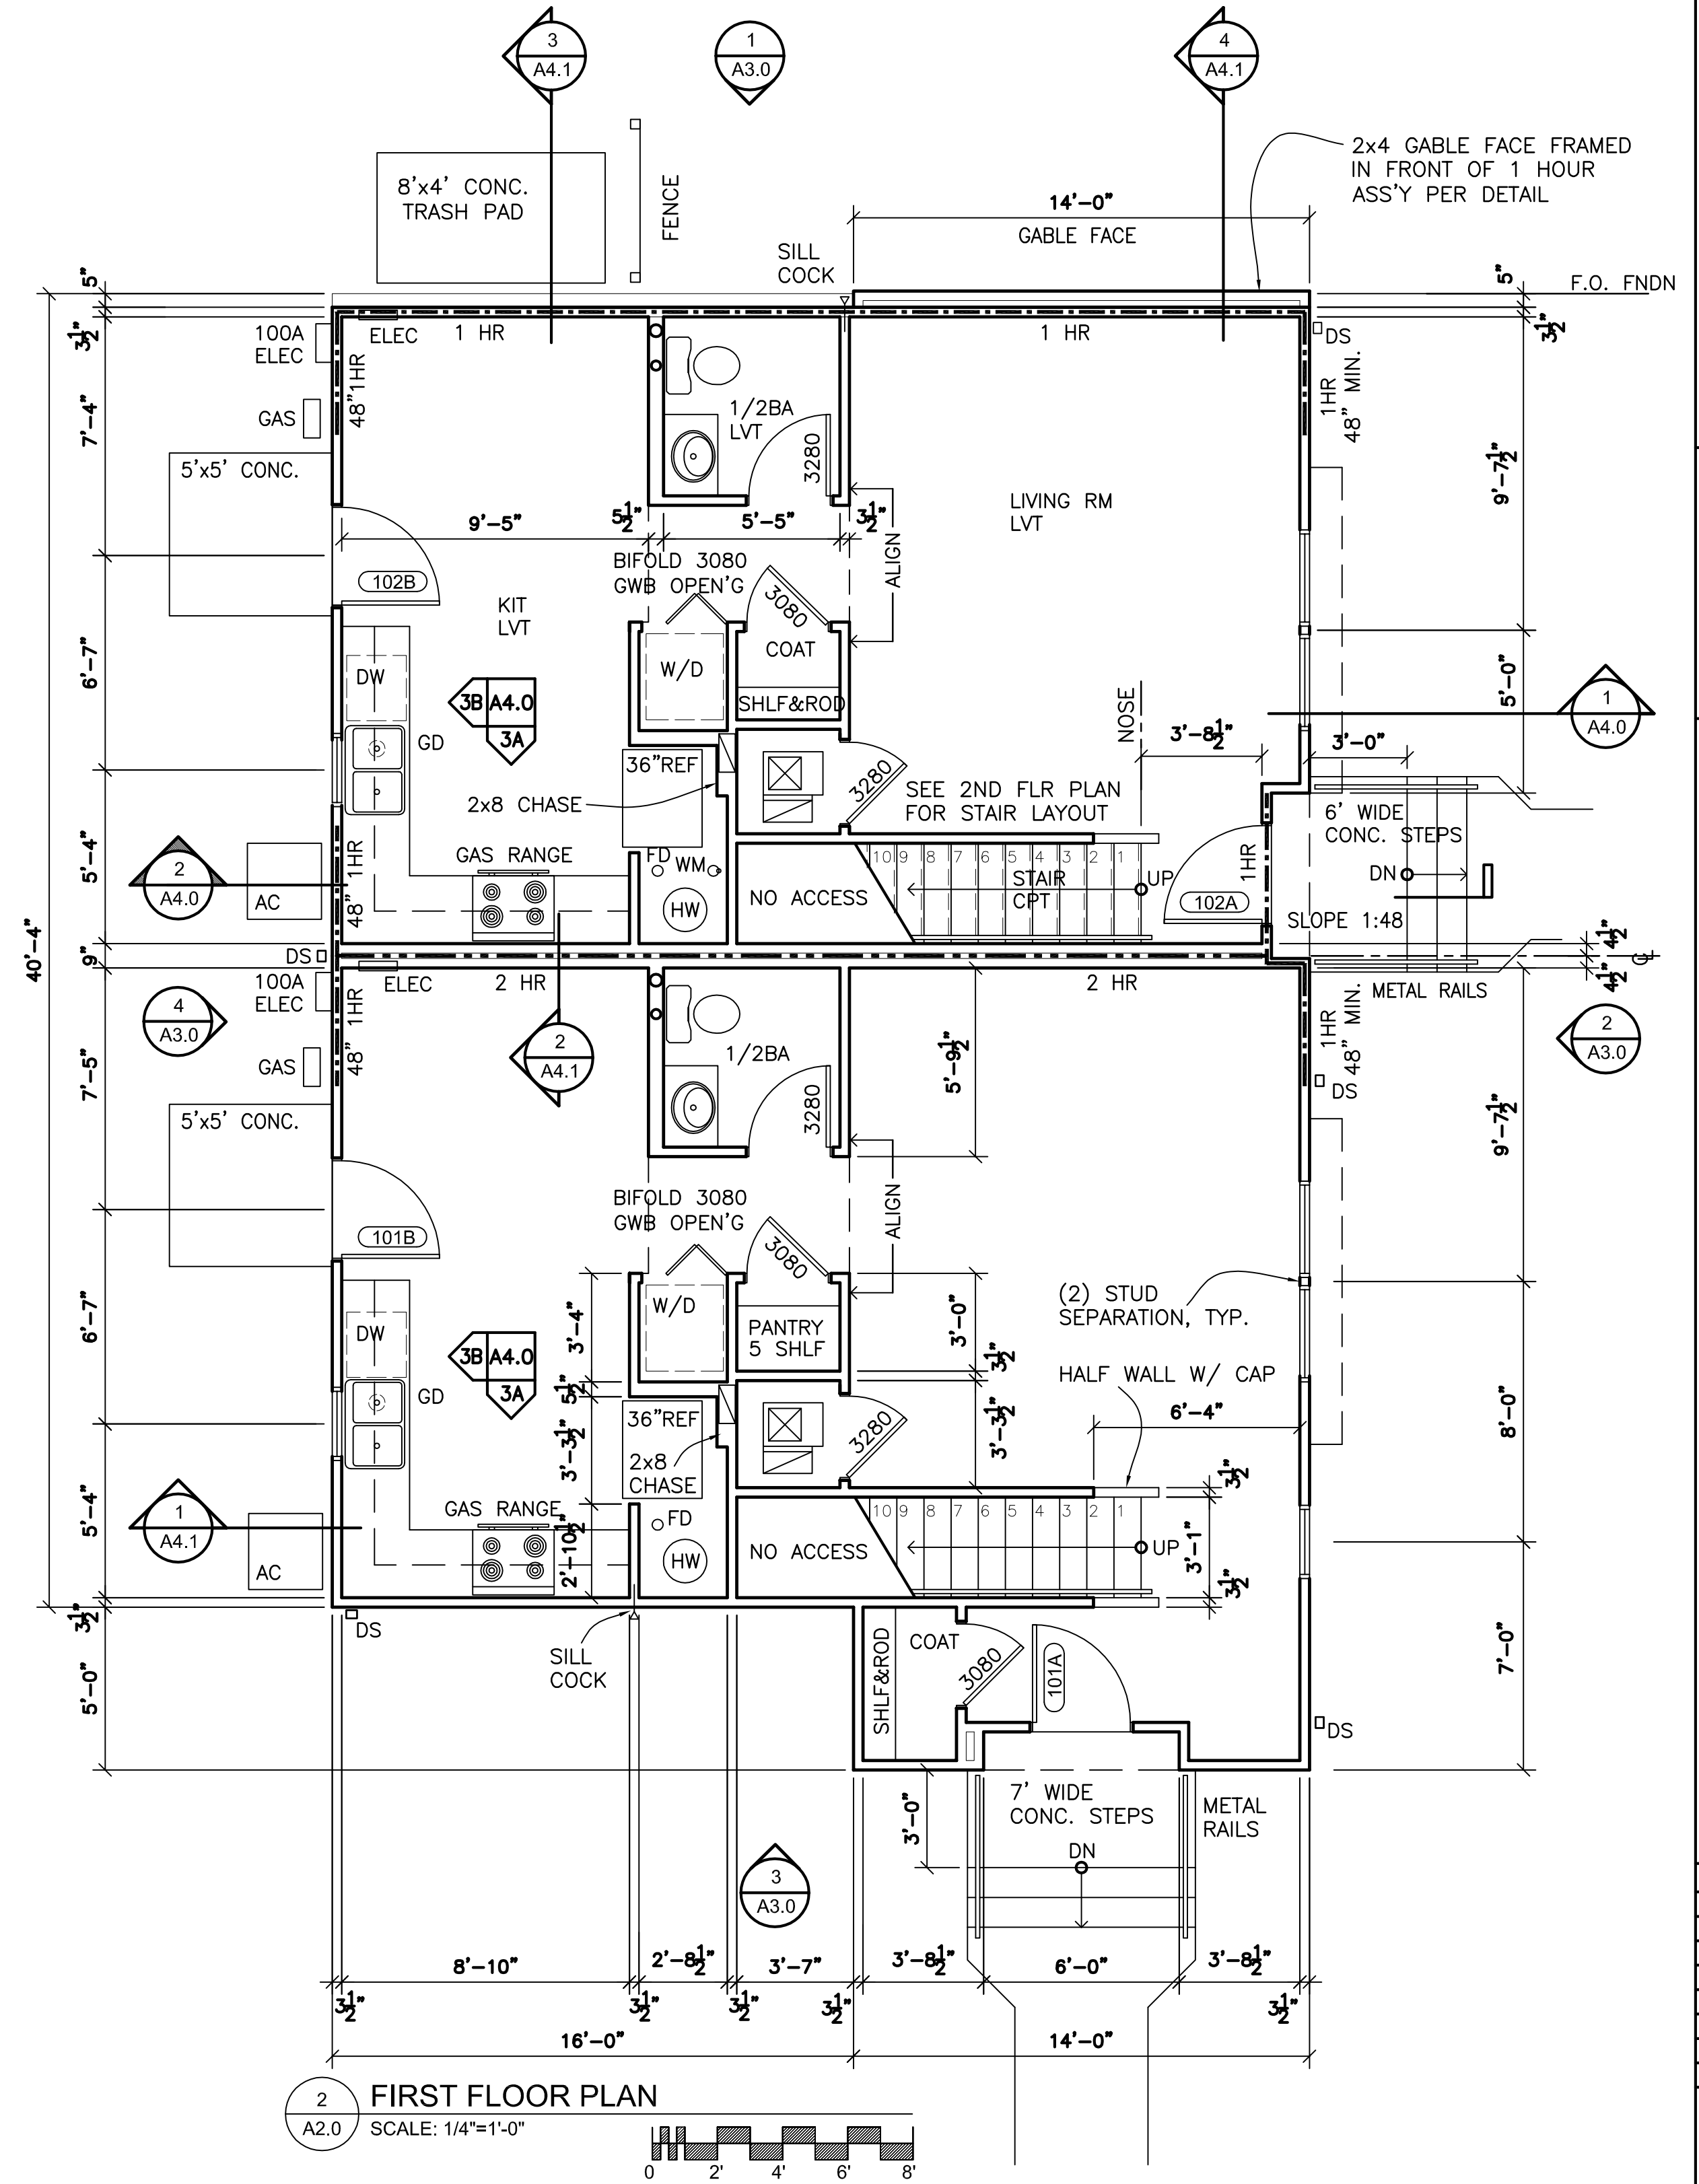

2 FIRST FLOOR PLAN
SCALE: 1/4"=1'-0"

NOT FOR CONSTRUCTION,
FOR COORDINATION ONLY
NO DRAWINGS DISPLAYING DATE OF ISSUANCE ON OR PRIOR TO
THIS SHOWN HERE ARE APPROVED FOR CONSTRUCTION

South Bend Heritage

803 LINCOLN WAY WEST
PHONE (574) 289 1066

SOUTH BEND, IN 46616
FAX (574) 289-4550

HOOSE COURT DUPLEX

227 S. SCOTT ST. & 703 W. WAYNE ST.

SOUTH BEND, IN 46601

REVISIONS	

Bid Set

Date: DEC. 17, 2020

Job Number:


Drafting: -

Approval: PDL

Foundation & First Floor Plan

Sheet Number:

A2.0

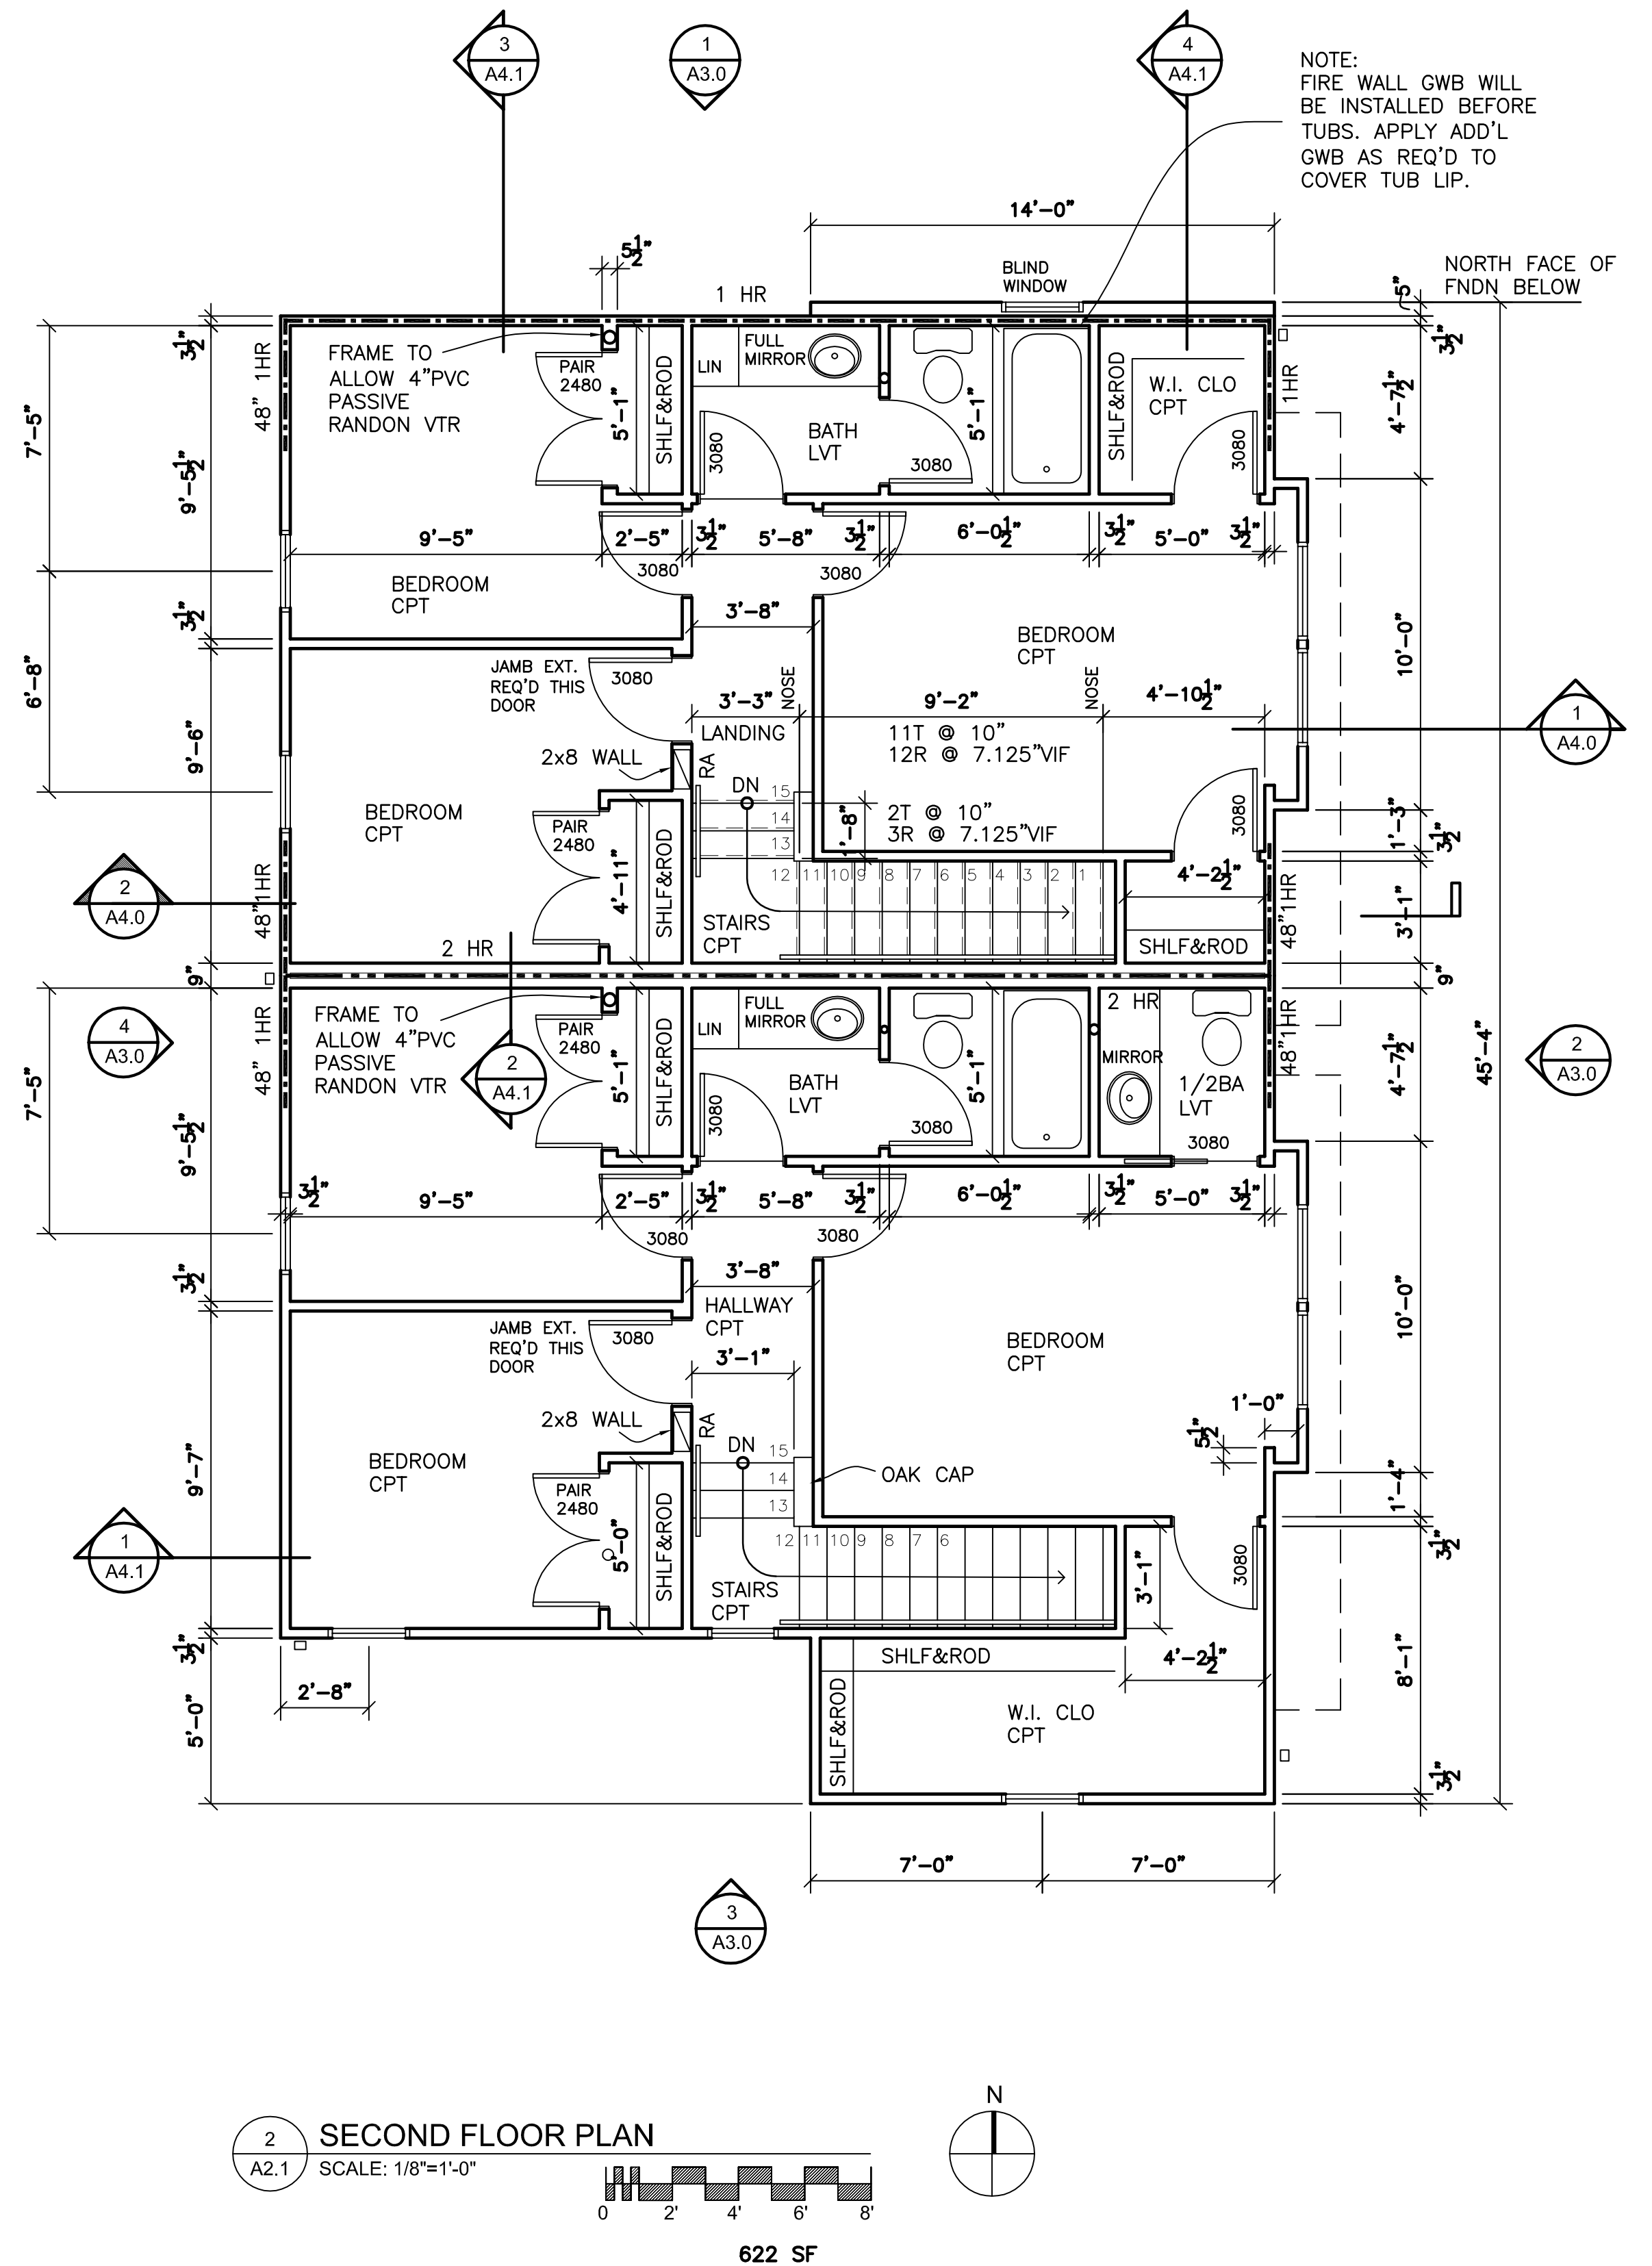

**NOT FOR CONSTRUCTION,
FOR COORDINATION ONLY**
NO DRAWINGS DISPLAYING DATE OF ISSUANCE ON OR PRIOR TO
THAT SHOWN HERE ARE APPROVED FOR CONSTRUCTION.

[illegible]



Bid Set	1	2	3	100
1	1	2	3	100

Date:	DEC. 17, 2020
Job Number:	
Drafting:	-
Approval:	PDL

2nd Flr Frm'g and Second Floor Plan

Sheet Number:

A2.1

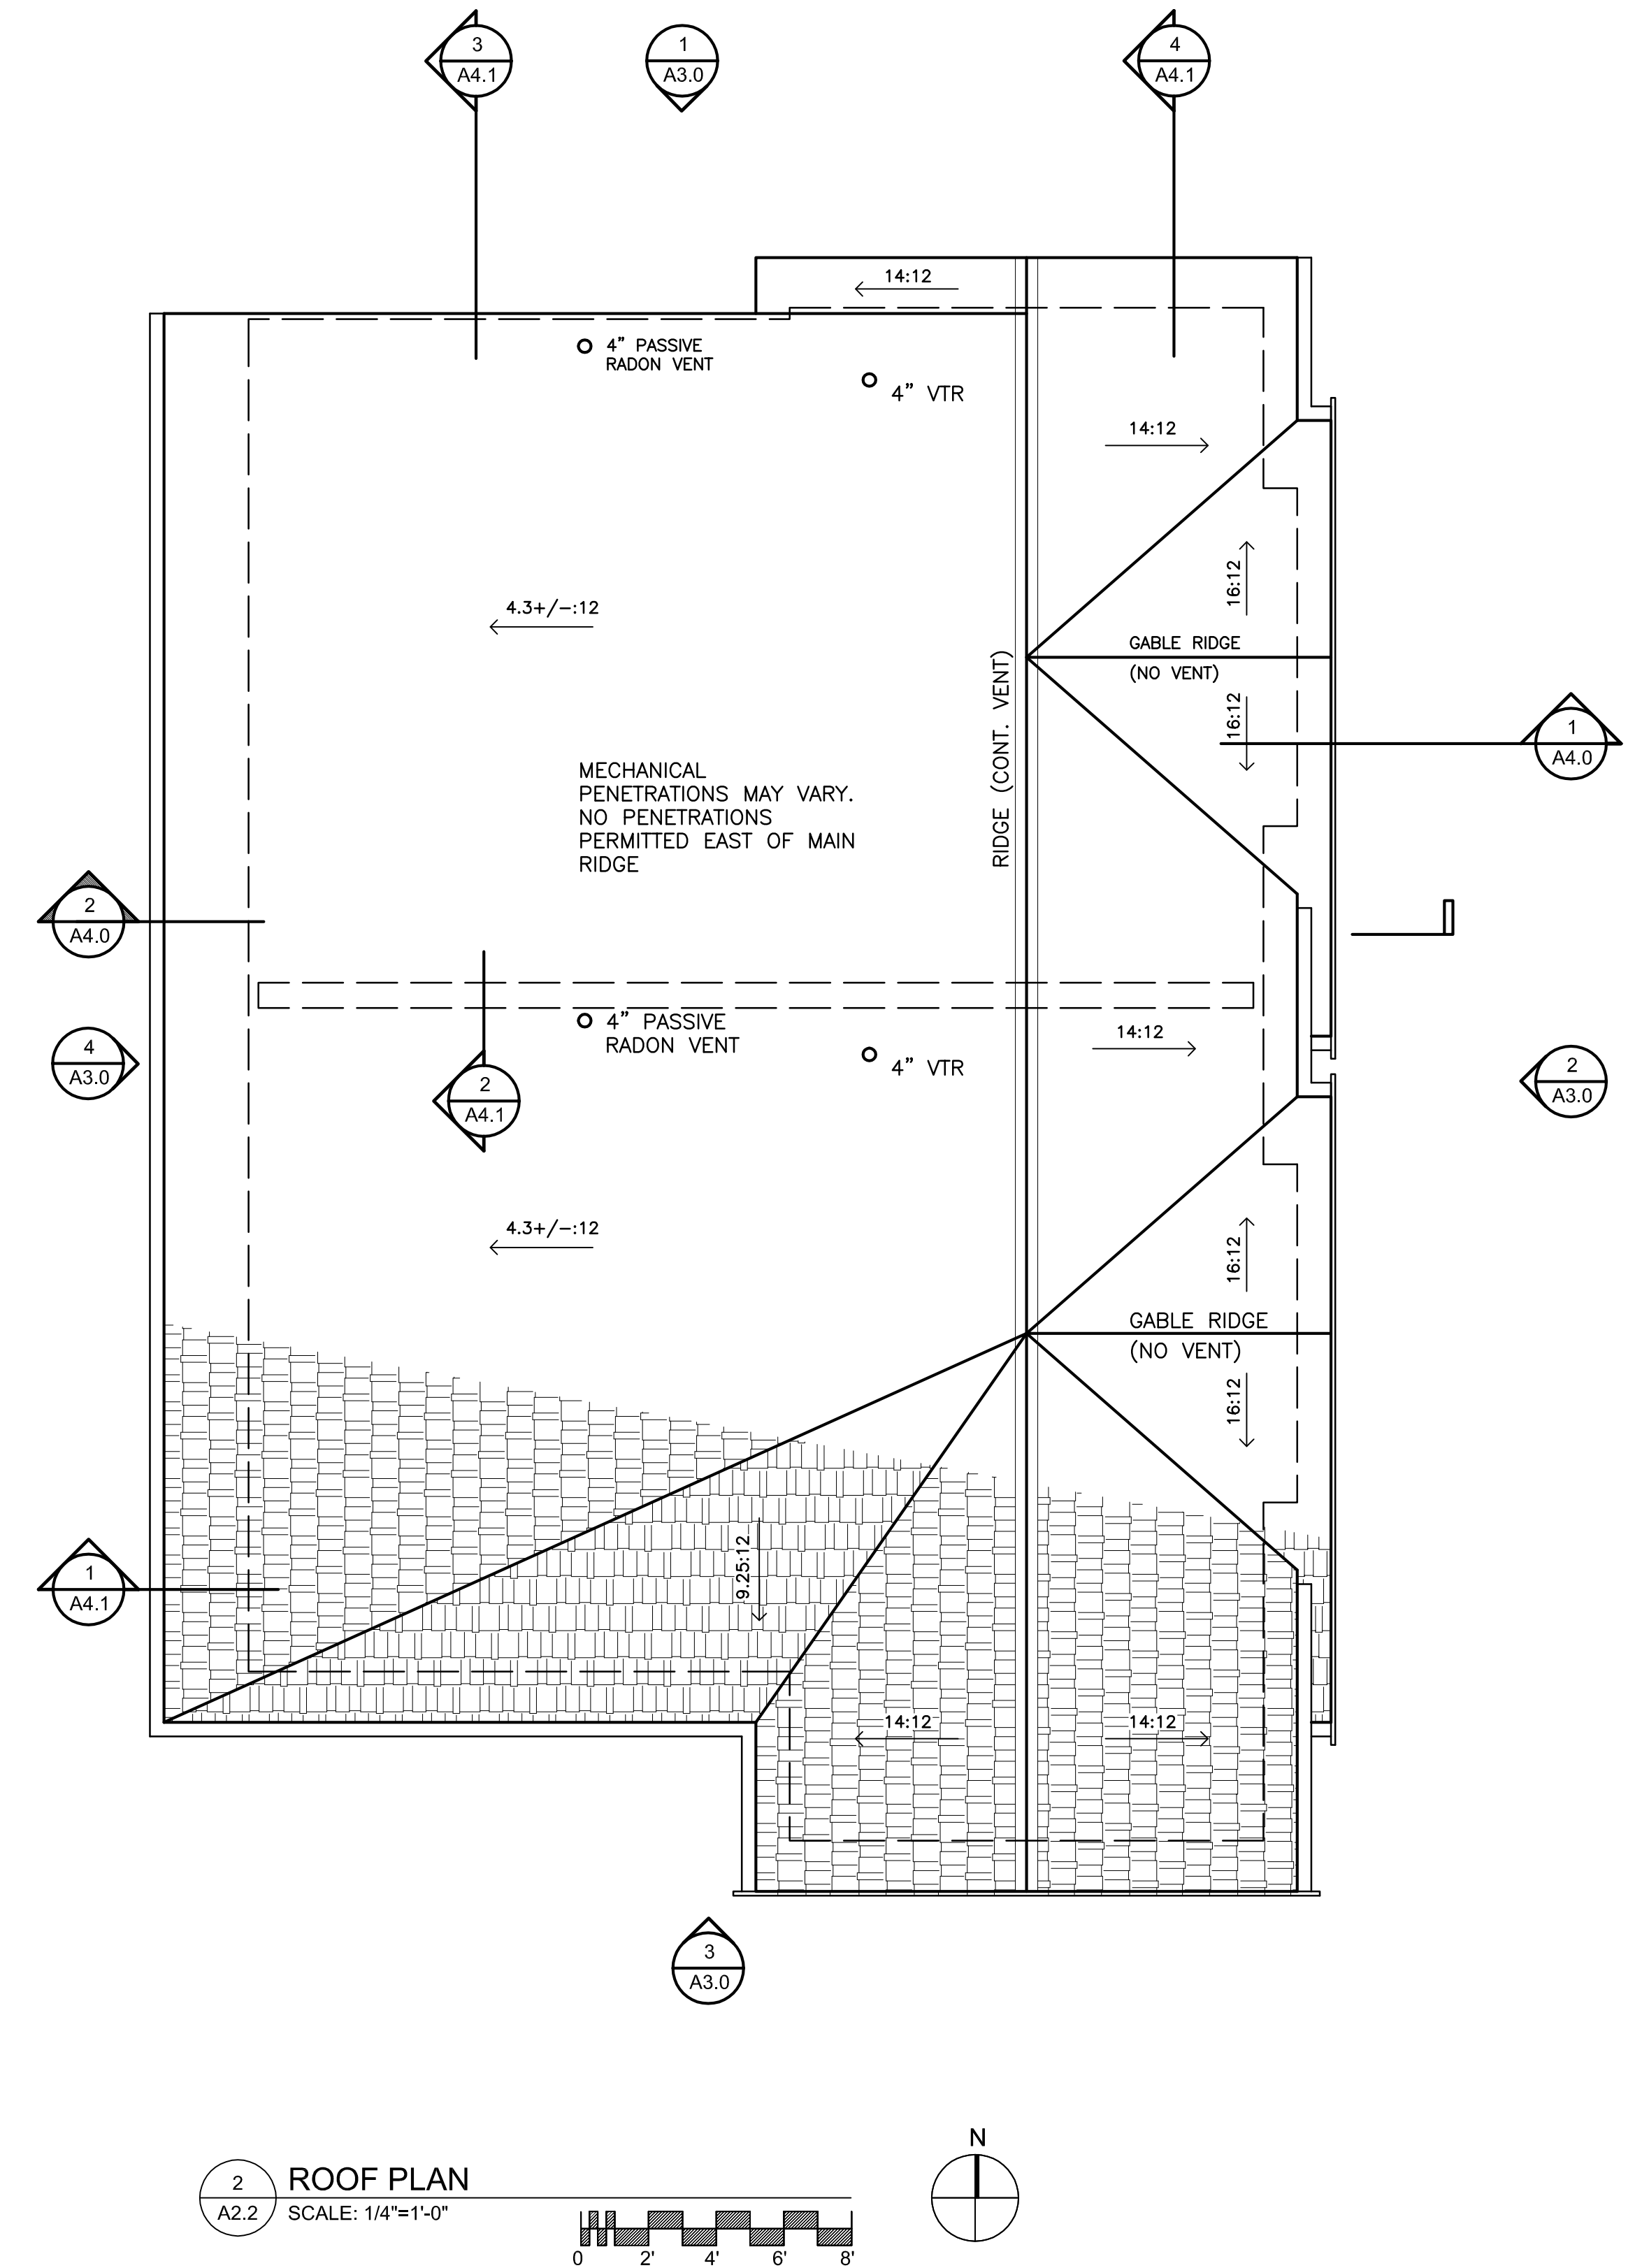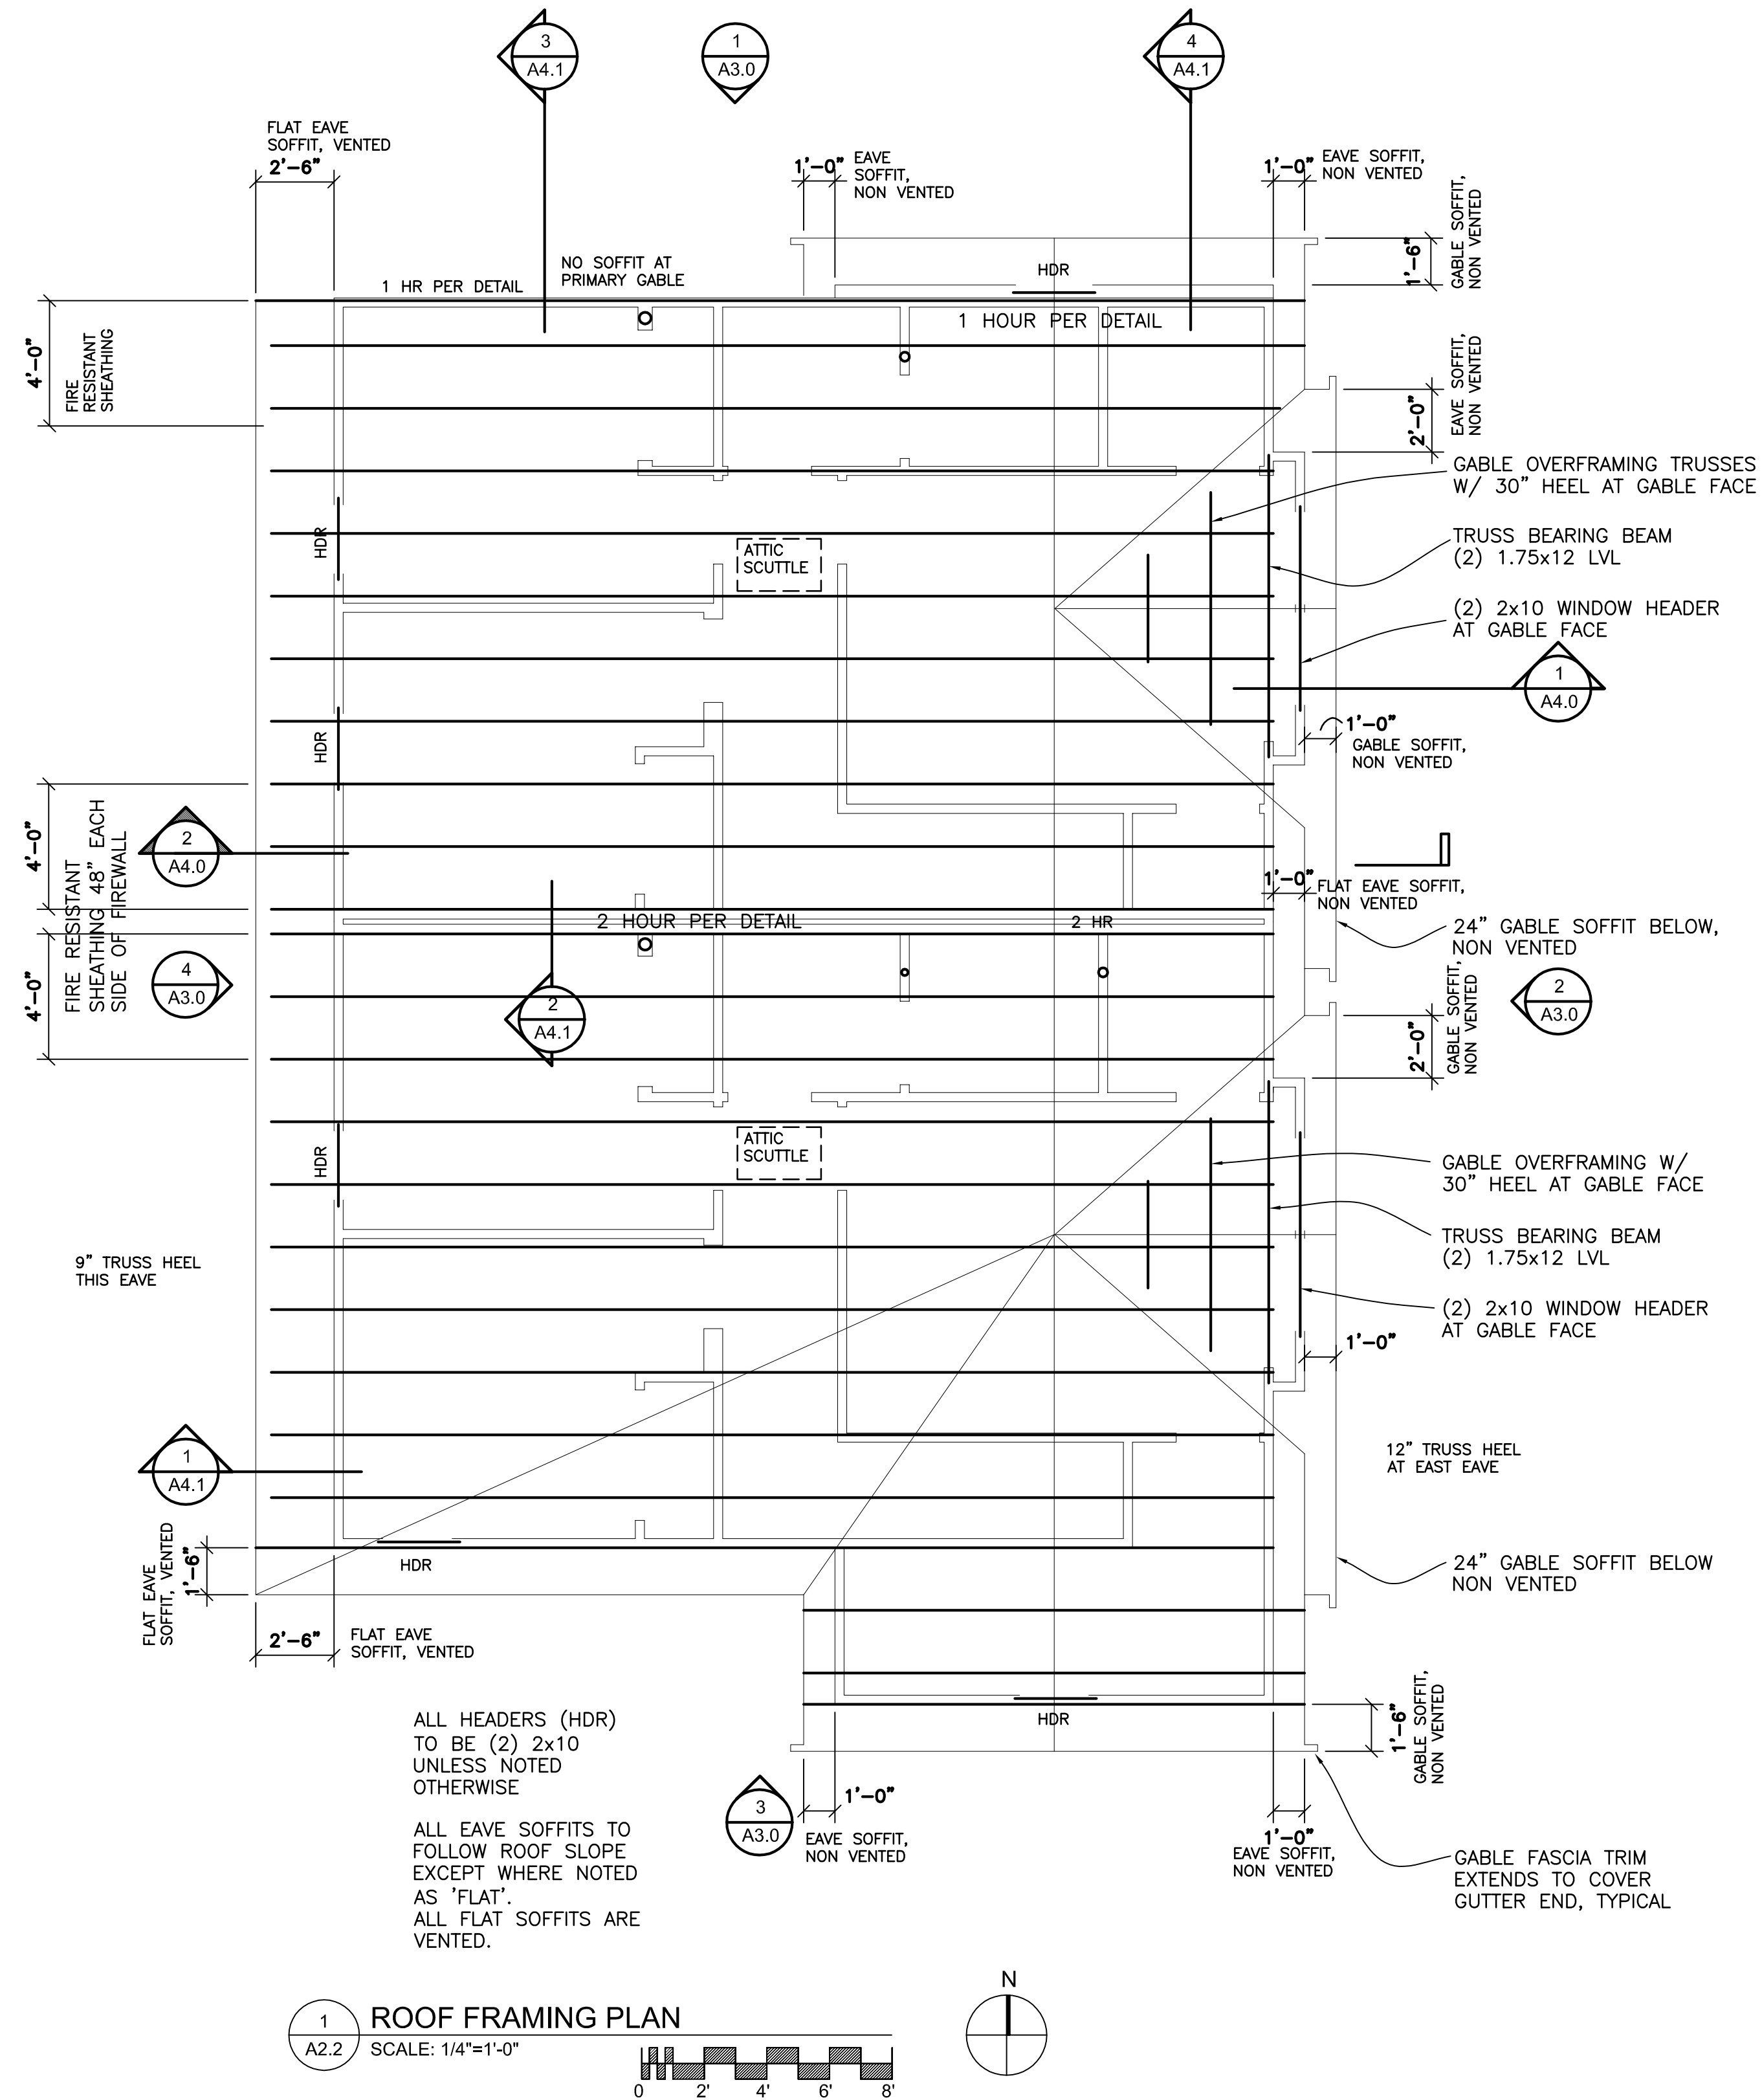

**NOT FOR CONSTRUCTION,
FOR COORDINATION ONLY**
NO DRAWINGS DISPLAYING DATE OF ISSUANCE ON OR PRIOR TO
THAT SHOWN HERE ARE APPROVED FOR CONSTRUCTION

[illegible]

Bid Set	
Date:	DEC. 17, 2020
Job Number:	
Drafting:	-
Approval:	PDL

Roof Trusses & Roof Plan

Sheet Number:


A2.2

South Bend Heritage


803 LINCOLN WAY WEST
PHONE (574) 289 1066

SOUTH BEND, IN 46616
FAX (574) 289-4550

HOOSE COURT DUPLEX
227 S. SCOTT ST. & 703 W. WAYNE ST.
SOUTH BEND, IN 46601

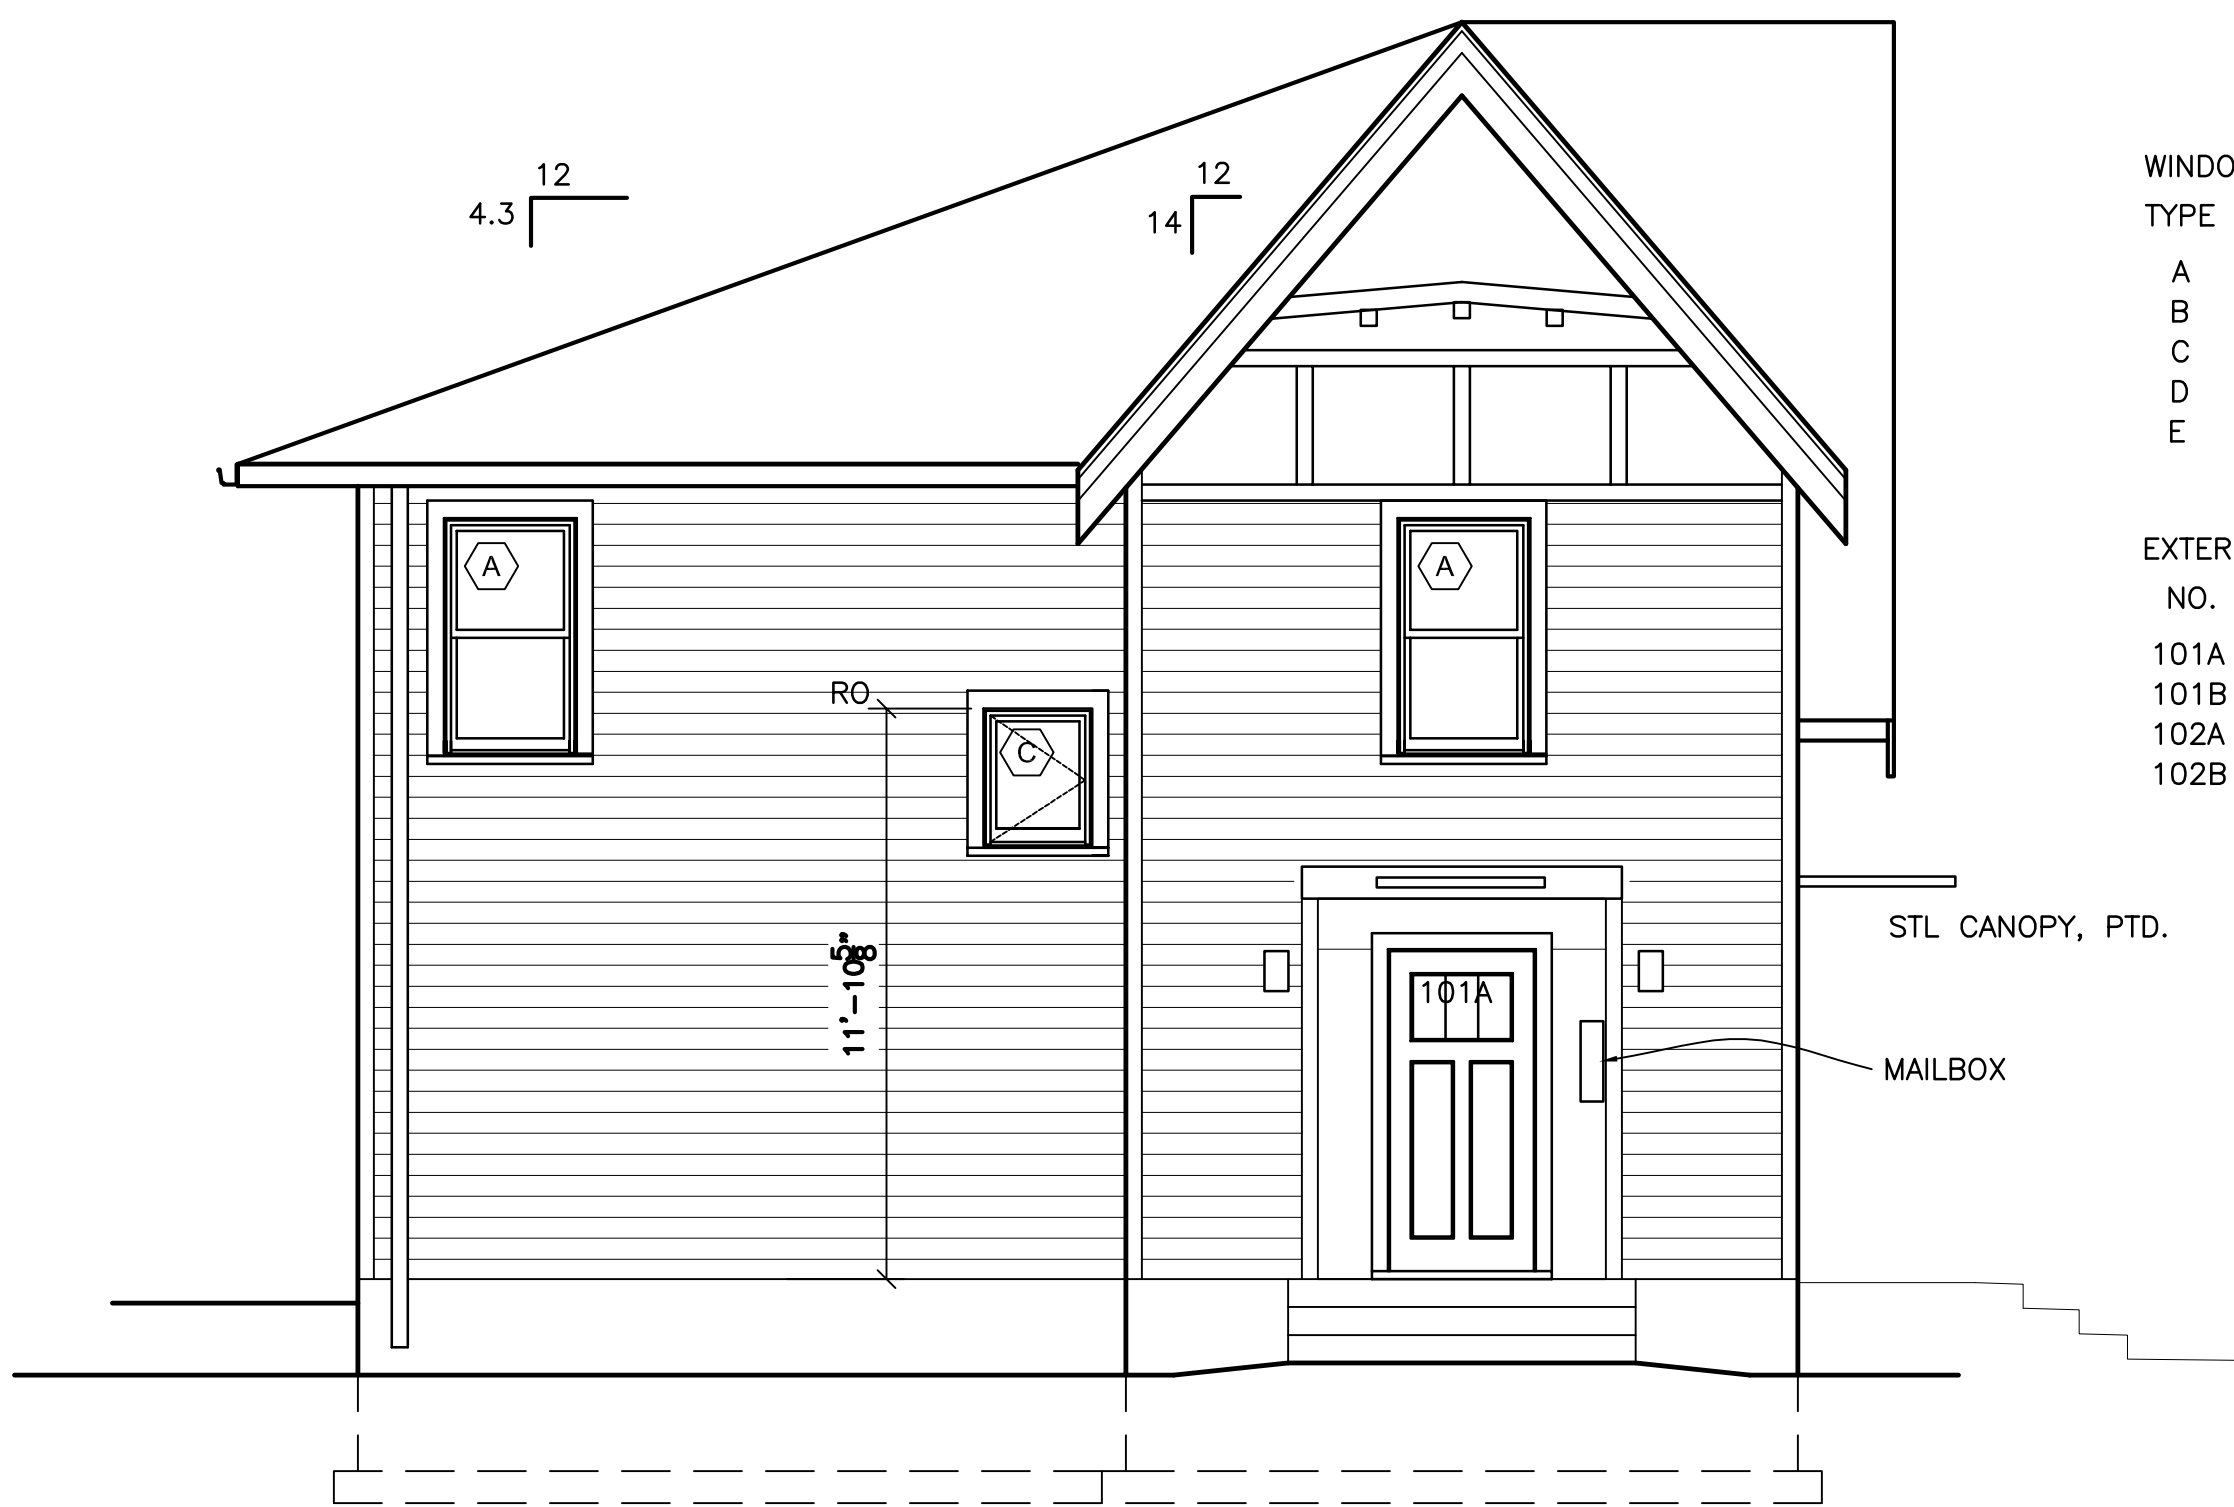

3 SOUTH ELEVATION
A3.0 SCALE: 1/4"=1'-0"

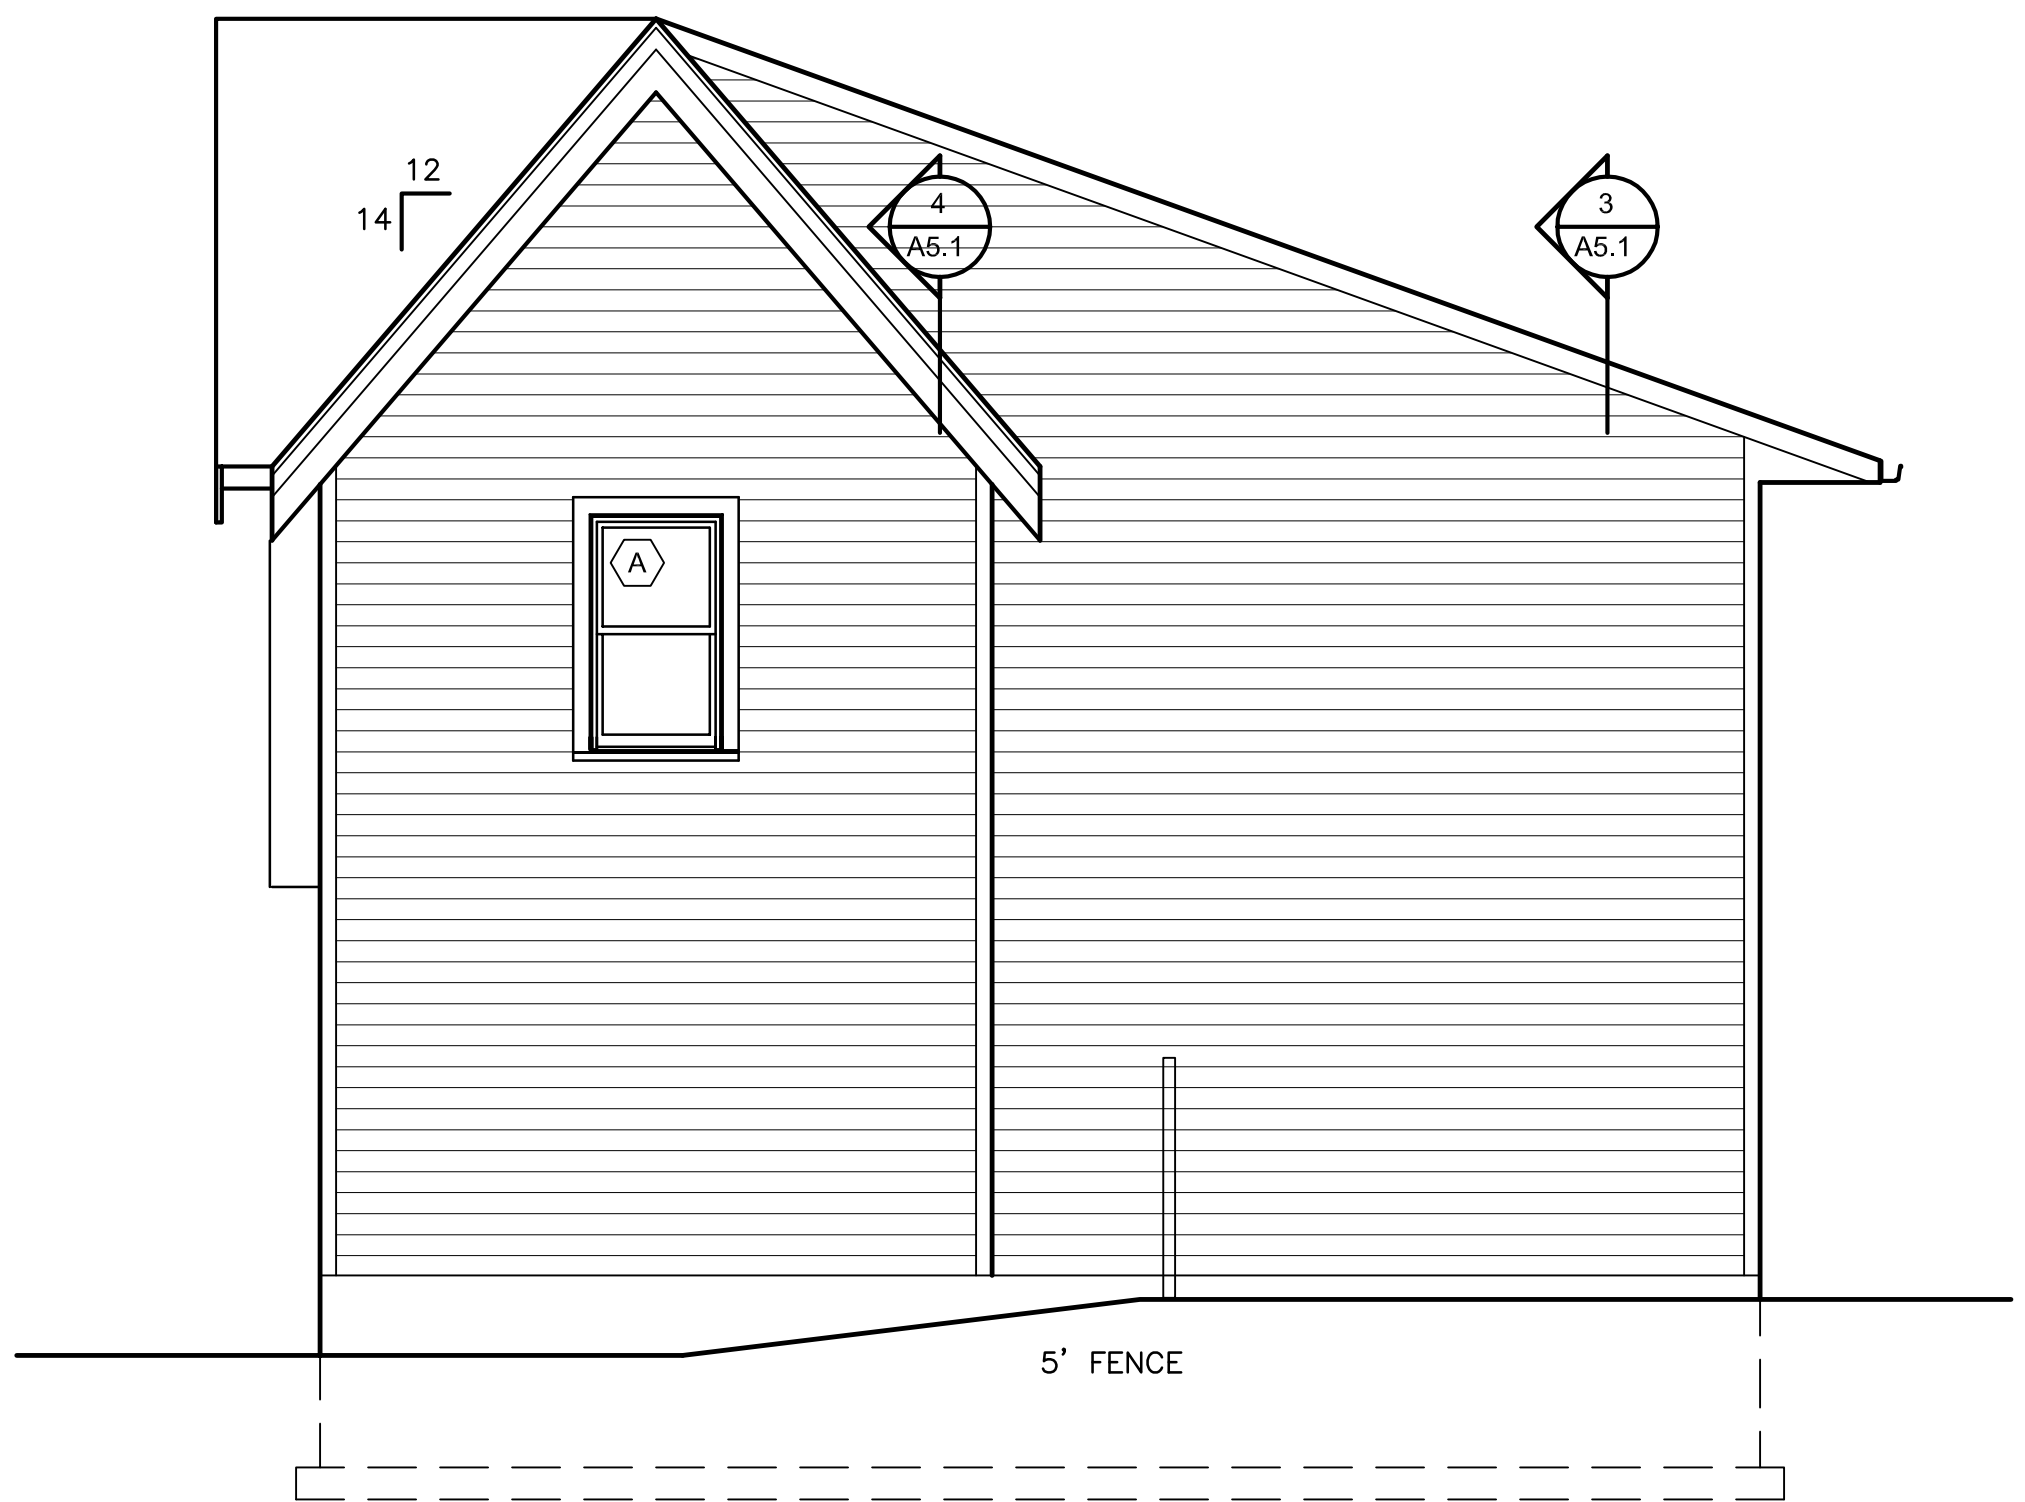


1 NORTH ELEVATION
A3.0 SCALE: 1/4"=1'-0"

WINDOWS		
TYPE	RO SIZE	QTY.
A	2'-9" X 4'-11"	6
B	2'-11" X 4'-11"	4
C	2'-3" X 2'-10"	2
D	2'-9" X 3'-8"	2
E	3'-6" X 4'-11"	4

EXTERIOR DOORS		
NO.	SIZE (VFY RO)	RATING
101A	3'-0" X 6'-8"	NONE
101B	3'-0" X 6'-8"	NONE
102A	3'-0" X 6'-8"	NONE (20 MIN. IF R2 OCC)
102B	3'-0" X 6'-8"	NONE



2 EAST ELEVATION
A3.0 SCALE: 1/4"=1'-0"

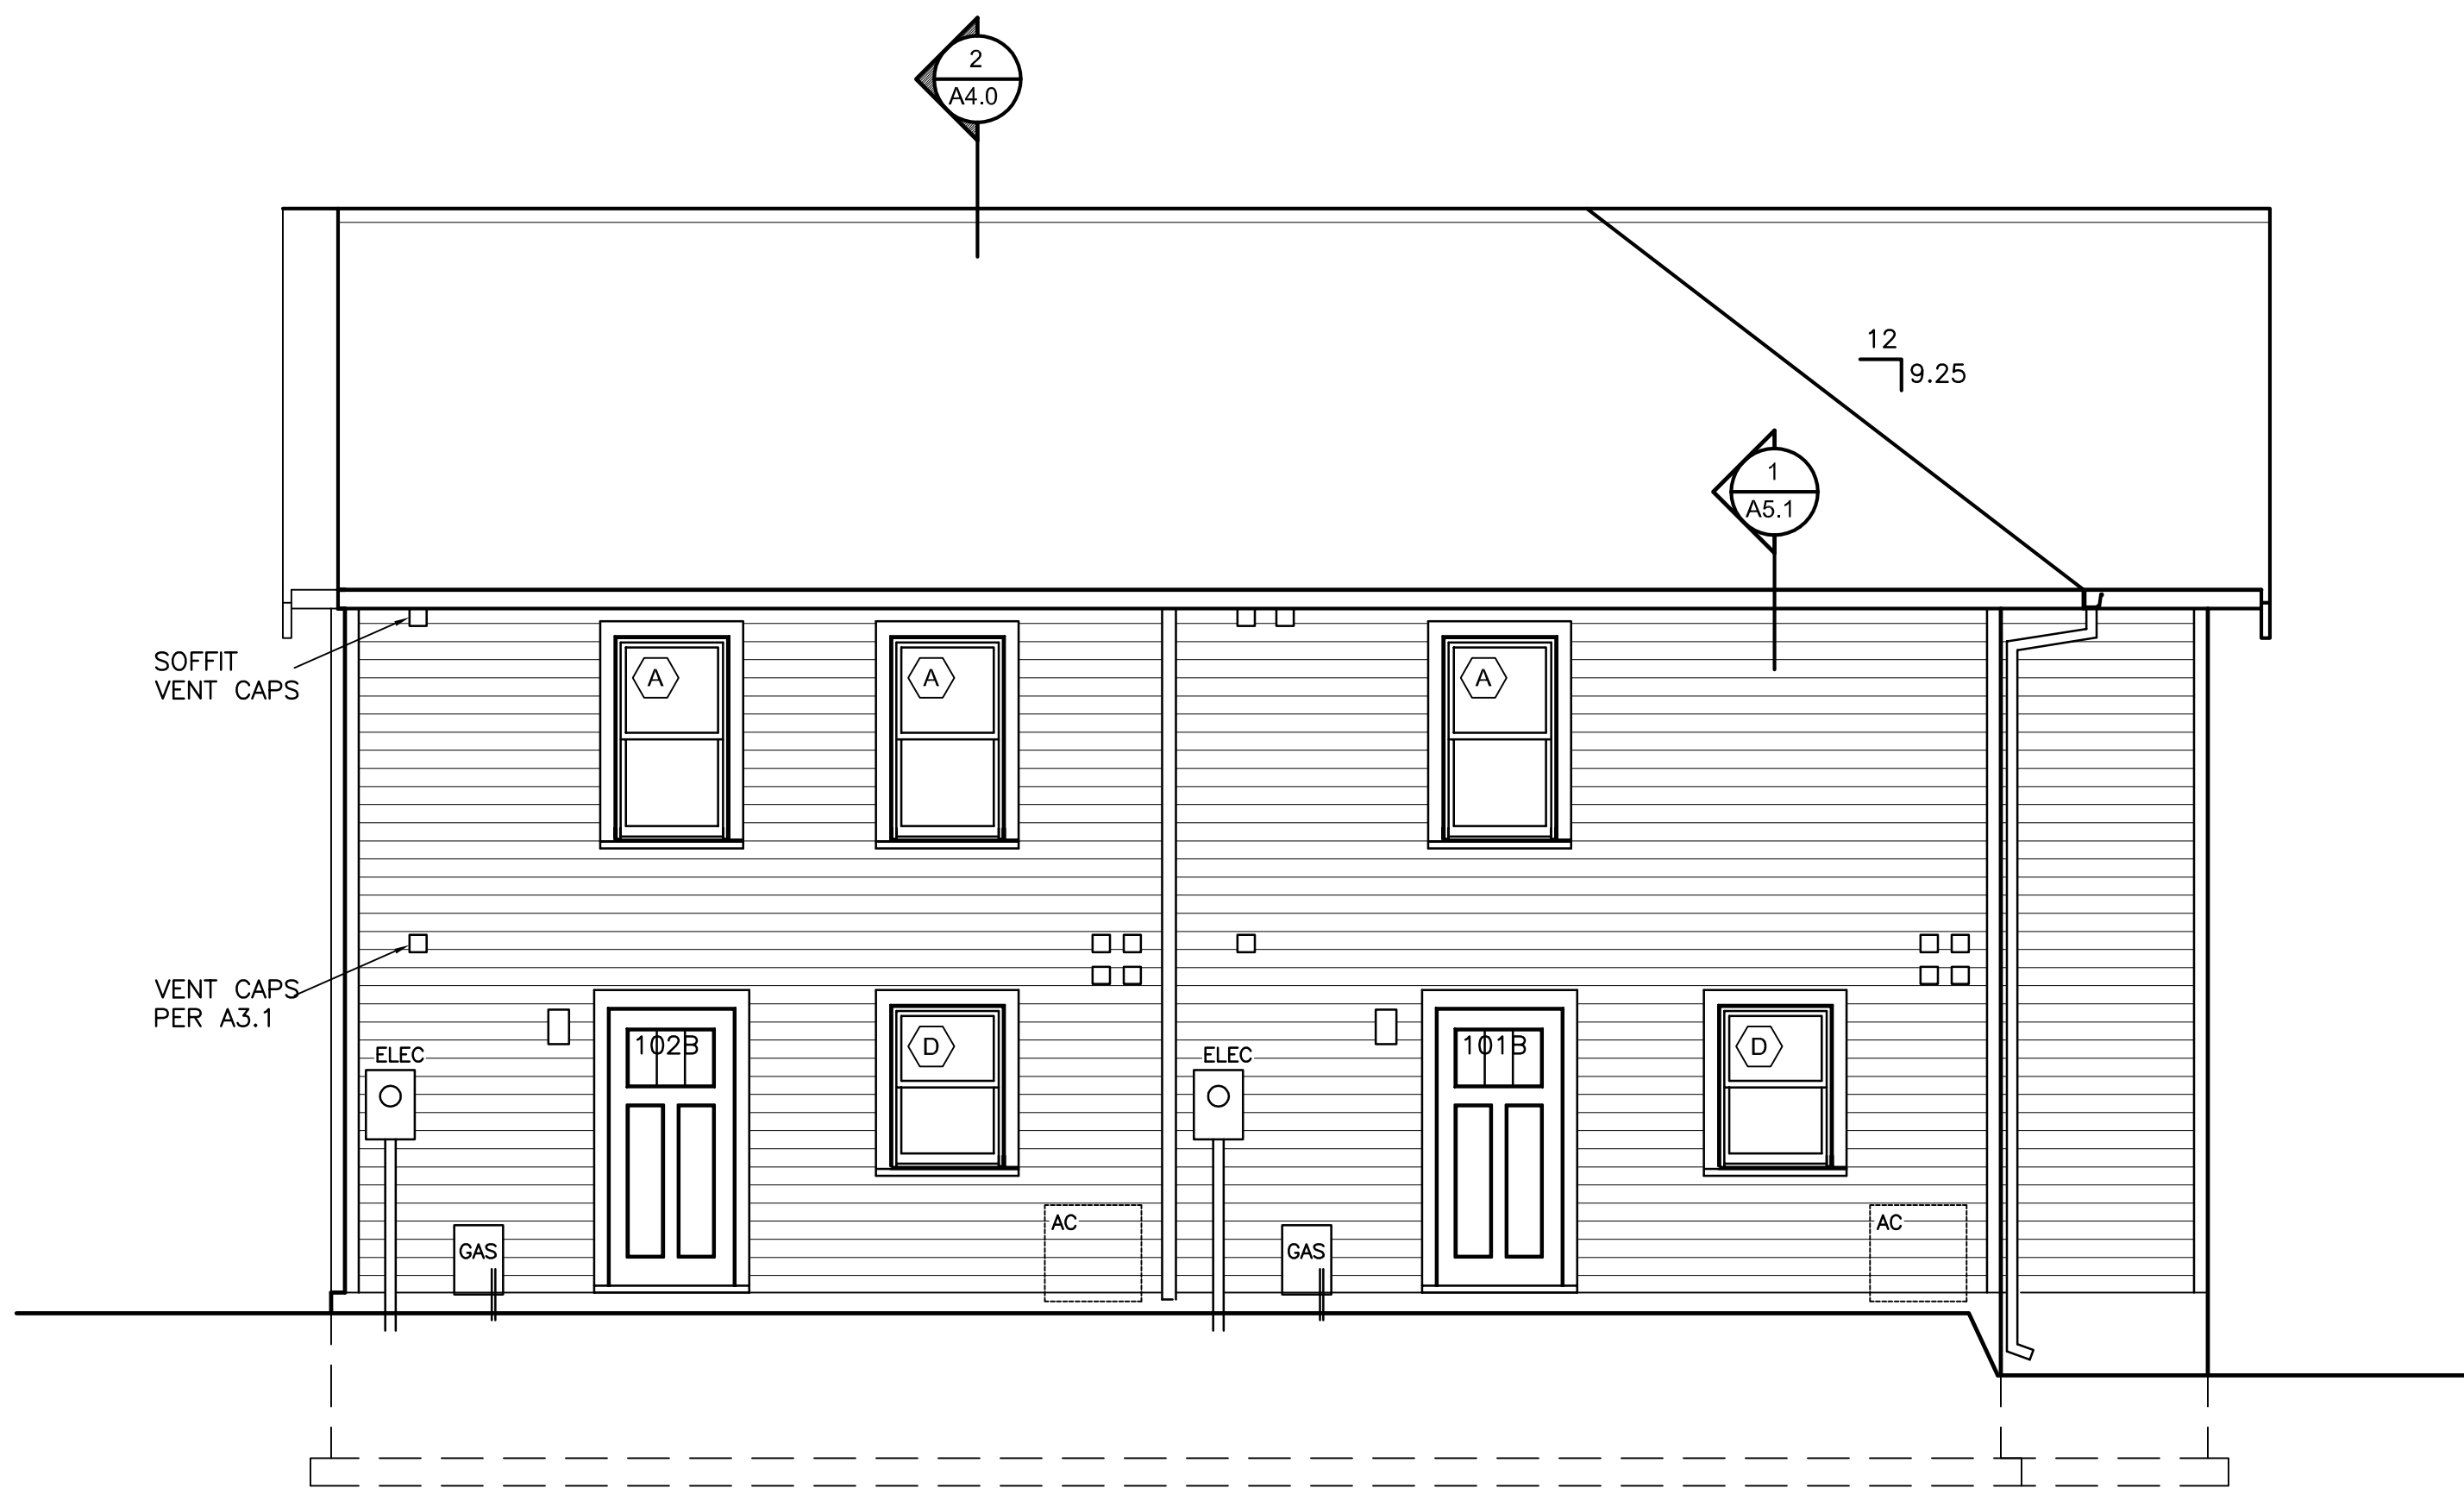

4 WEST ELEVATION
A3.0 SCALE: 1/4"=1'-0"

South Bend Heritage
803 LINCOLN WAY WEST SOUTH BEND, IN 46616
PHONE (574) 289 1086 FAX (574) 289 4550

HOOSE COURT DUPLEX
227 S. SCOTT ST. & 703 W. WAYNE ST.
SOUTH BEND, IN 46601


REVISIONS		

Bid Set
Date: DEC. 17, 2020
Job Number:
Drafting: -
Approval: PDL

Elevations & Window Sched.

Sheet Number:
A3.0

NOT FOR CONSTRUCTION
FOR COORDINATION ONLY
NO DRAWINGS DISPLAYING DATE OF ISSUANCE OR PRIOR TO THAT SHOWN HERE ARE APPROVED FOR CONSTRUCTION.

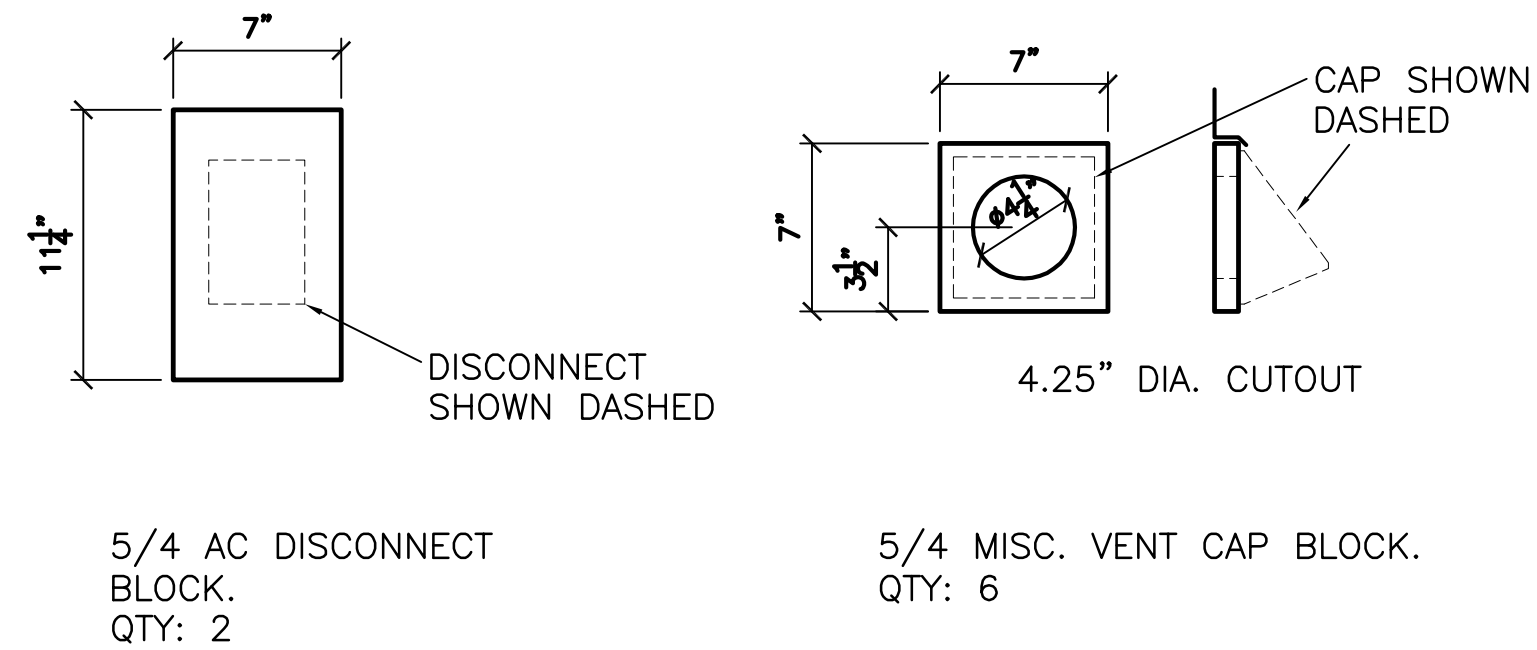


ALL FACTORY AND CUT EDGES TO BE PAINTED
COLOR OF HOUSE TRIM.

WATER HEATER EXHAUST AND FURNACE VENT PIPES DO NOT
REQUIRE ESCUTCHION TRIM BLOCKS.

ALL PENETRATIONS THROUGH TYVEK TO BE AIR
SEALED PER SPEC.

ALUM. FLG OVER TOP OF ALL TRIM BLOCKS NOTED HERE.

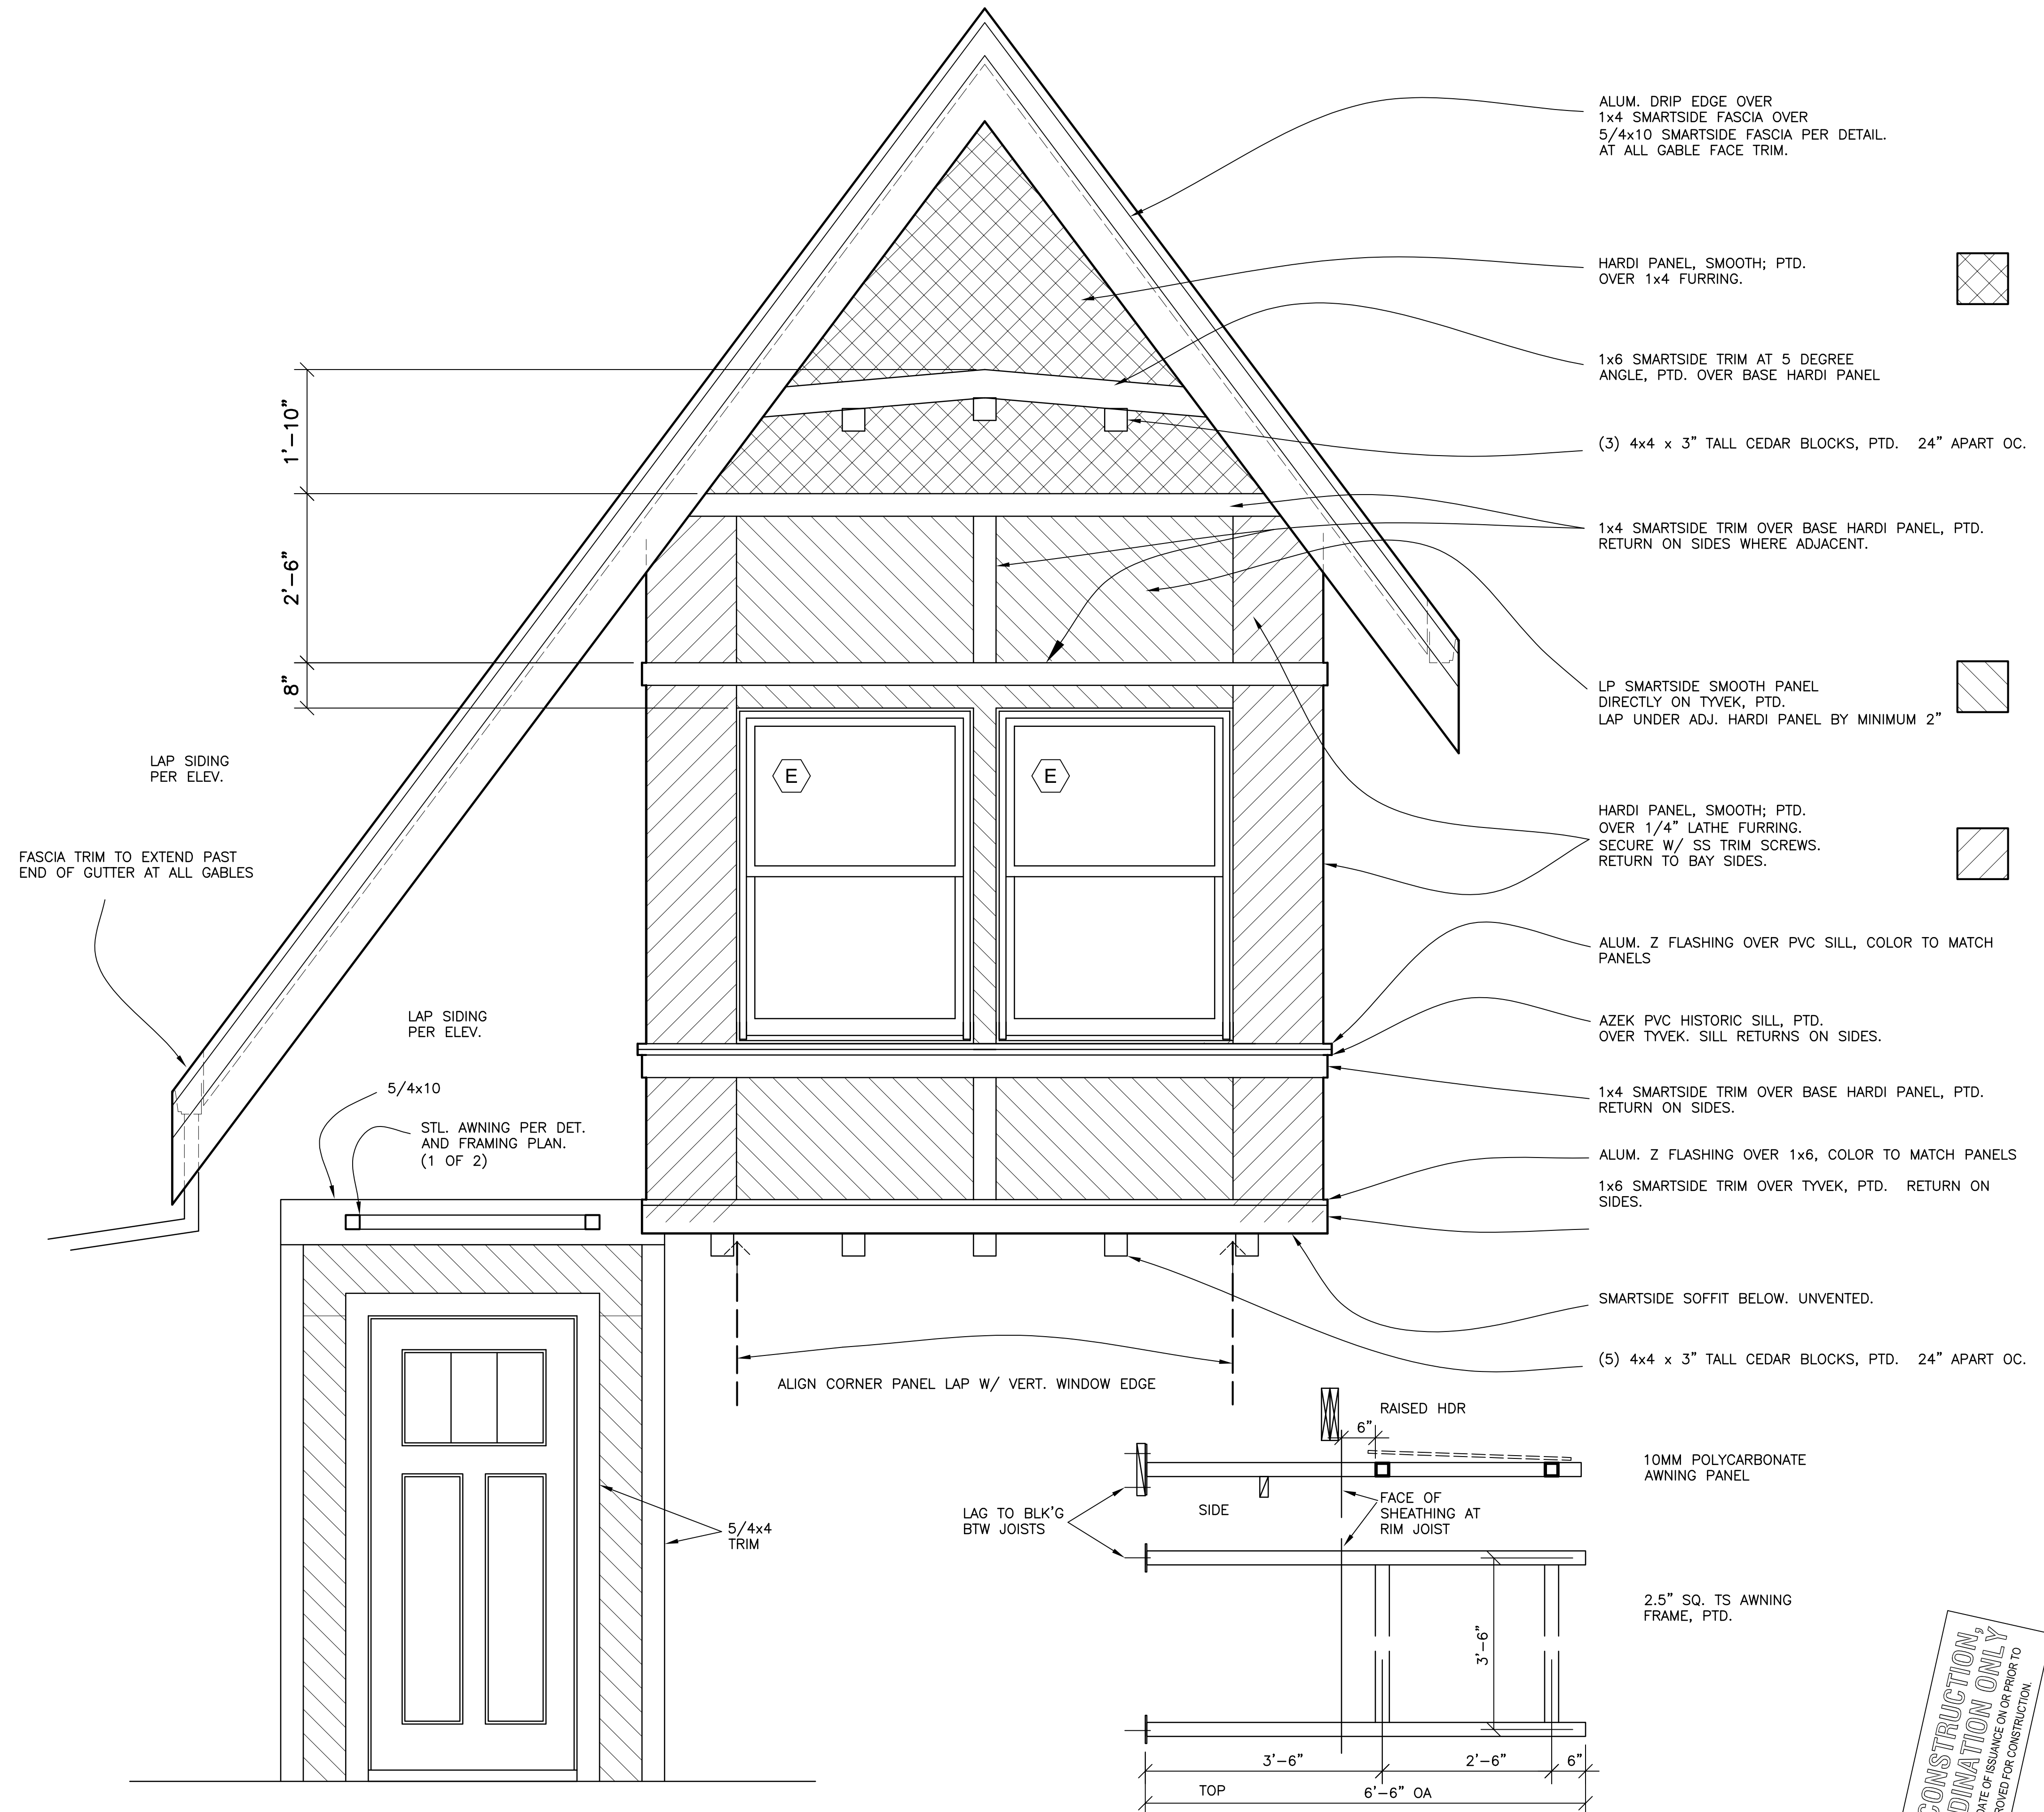

1 GABLE SIDING DETAIL
A3.1 SCALE: 3/4"=1'-0"

**NOT FOR CONSTRUCTION
FOR COORDINATION ONLY**
NO DRAWINGS DISPLAYING DATE OF ISSUANCE ON OR PRIOR TO
THAT SHOWN HERE ARE APPROVED FOR CONSTRUCTION





[illegible]

Bid Set	
Date:	DEC. 17, 2020
Job Number:	
Drafting:	-
Approval:	PDL

Detail Elevations

Sheet Number:

A3.1

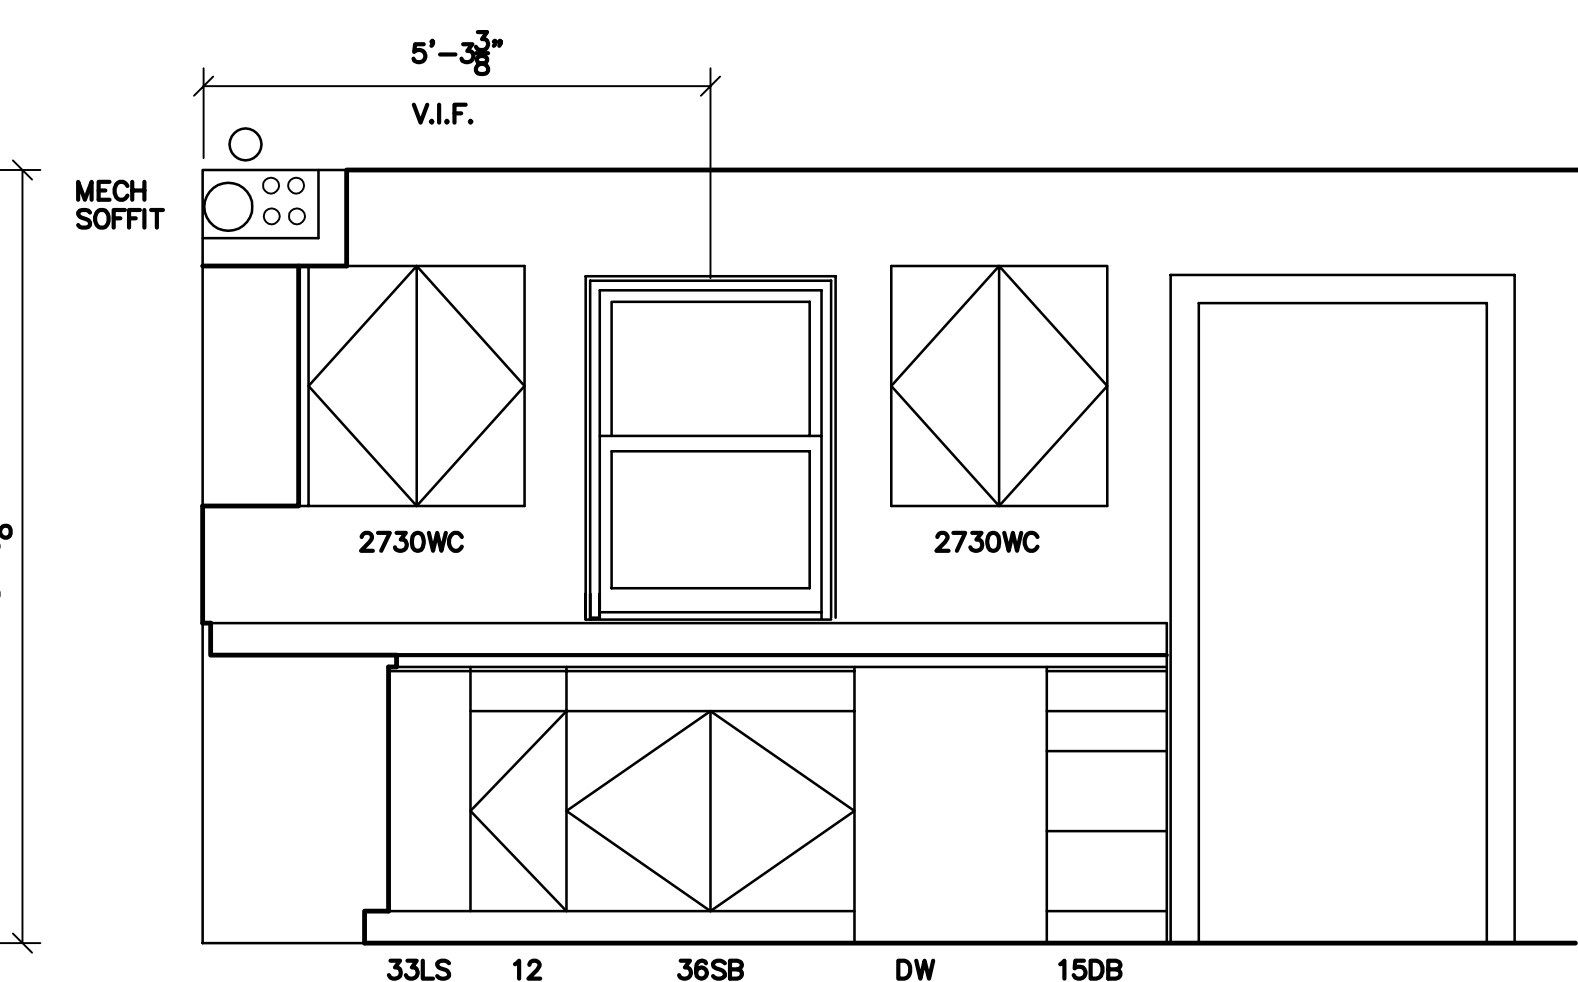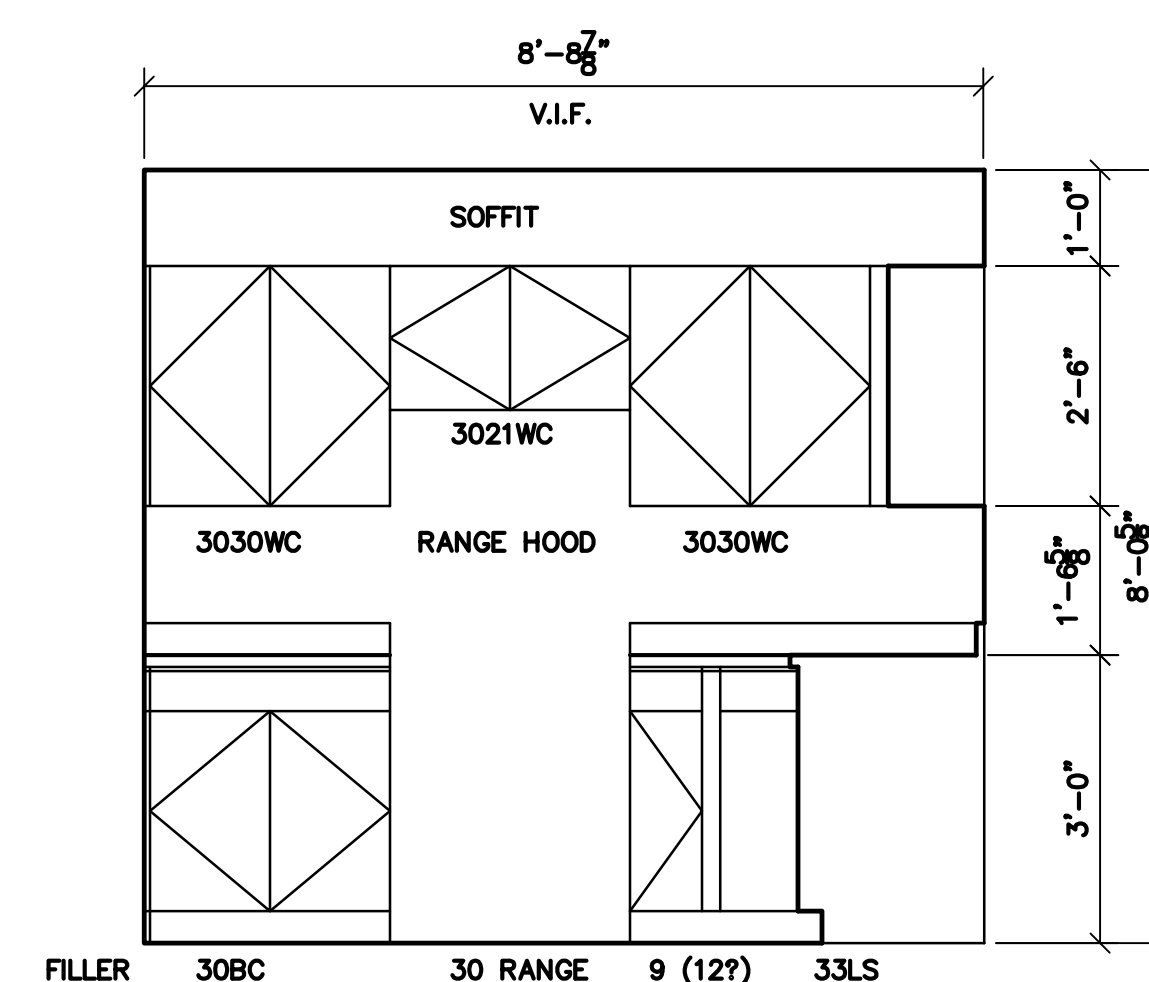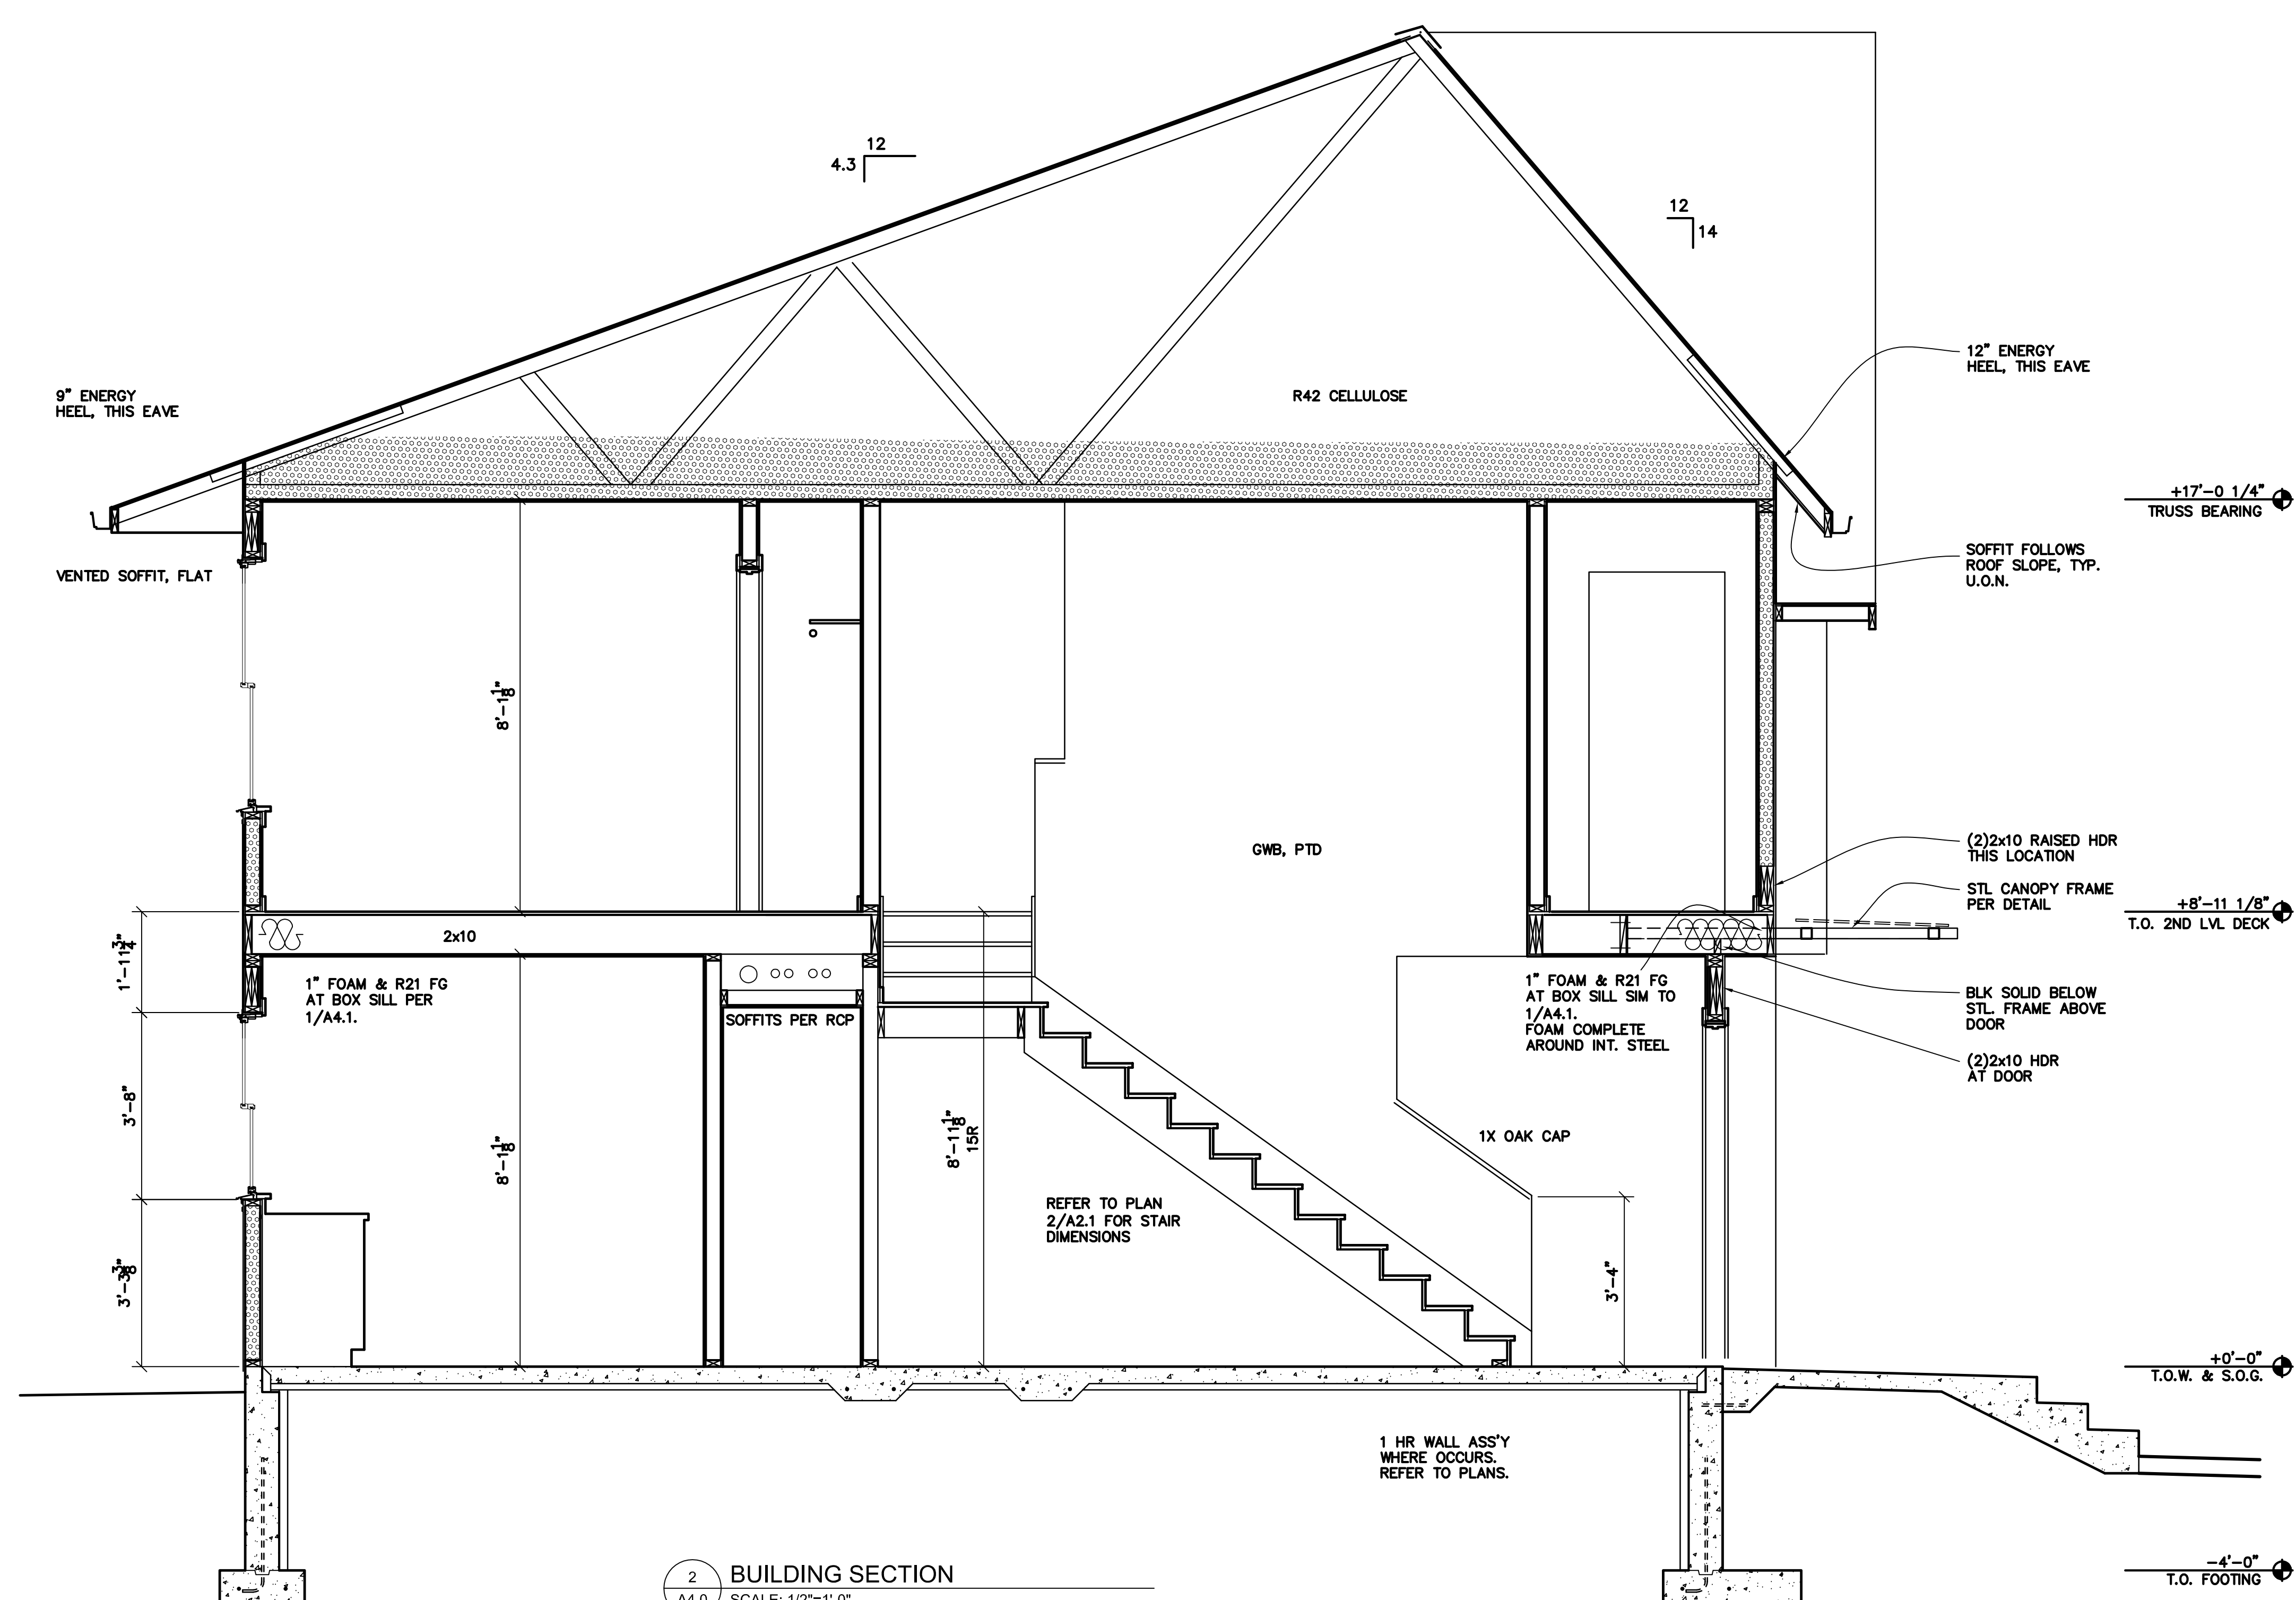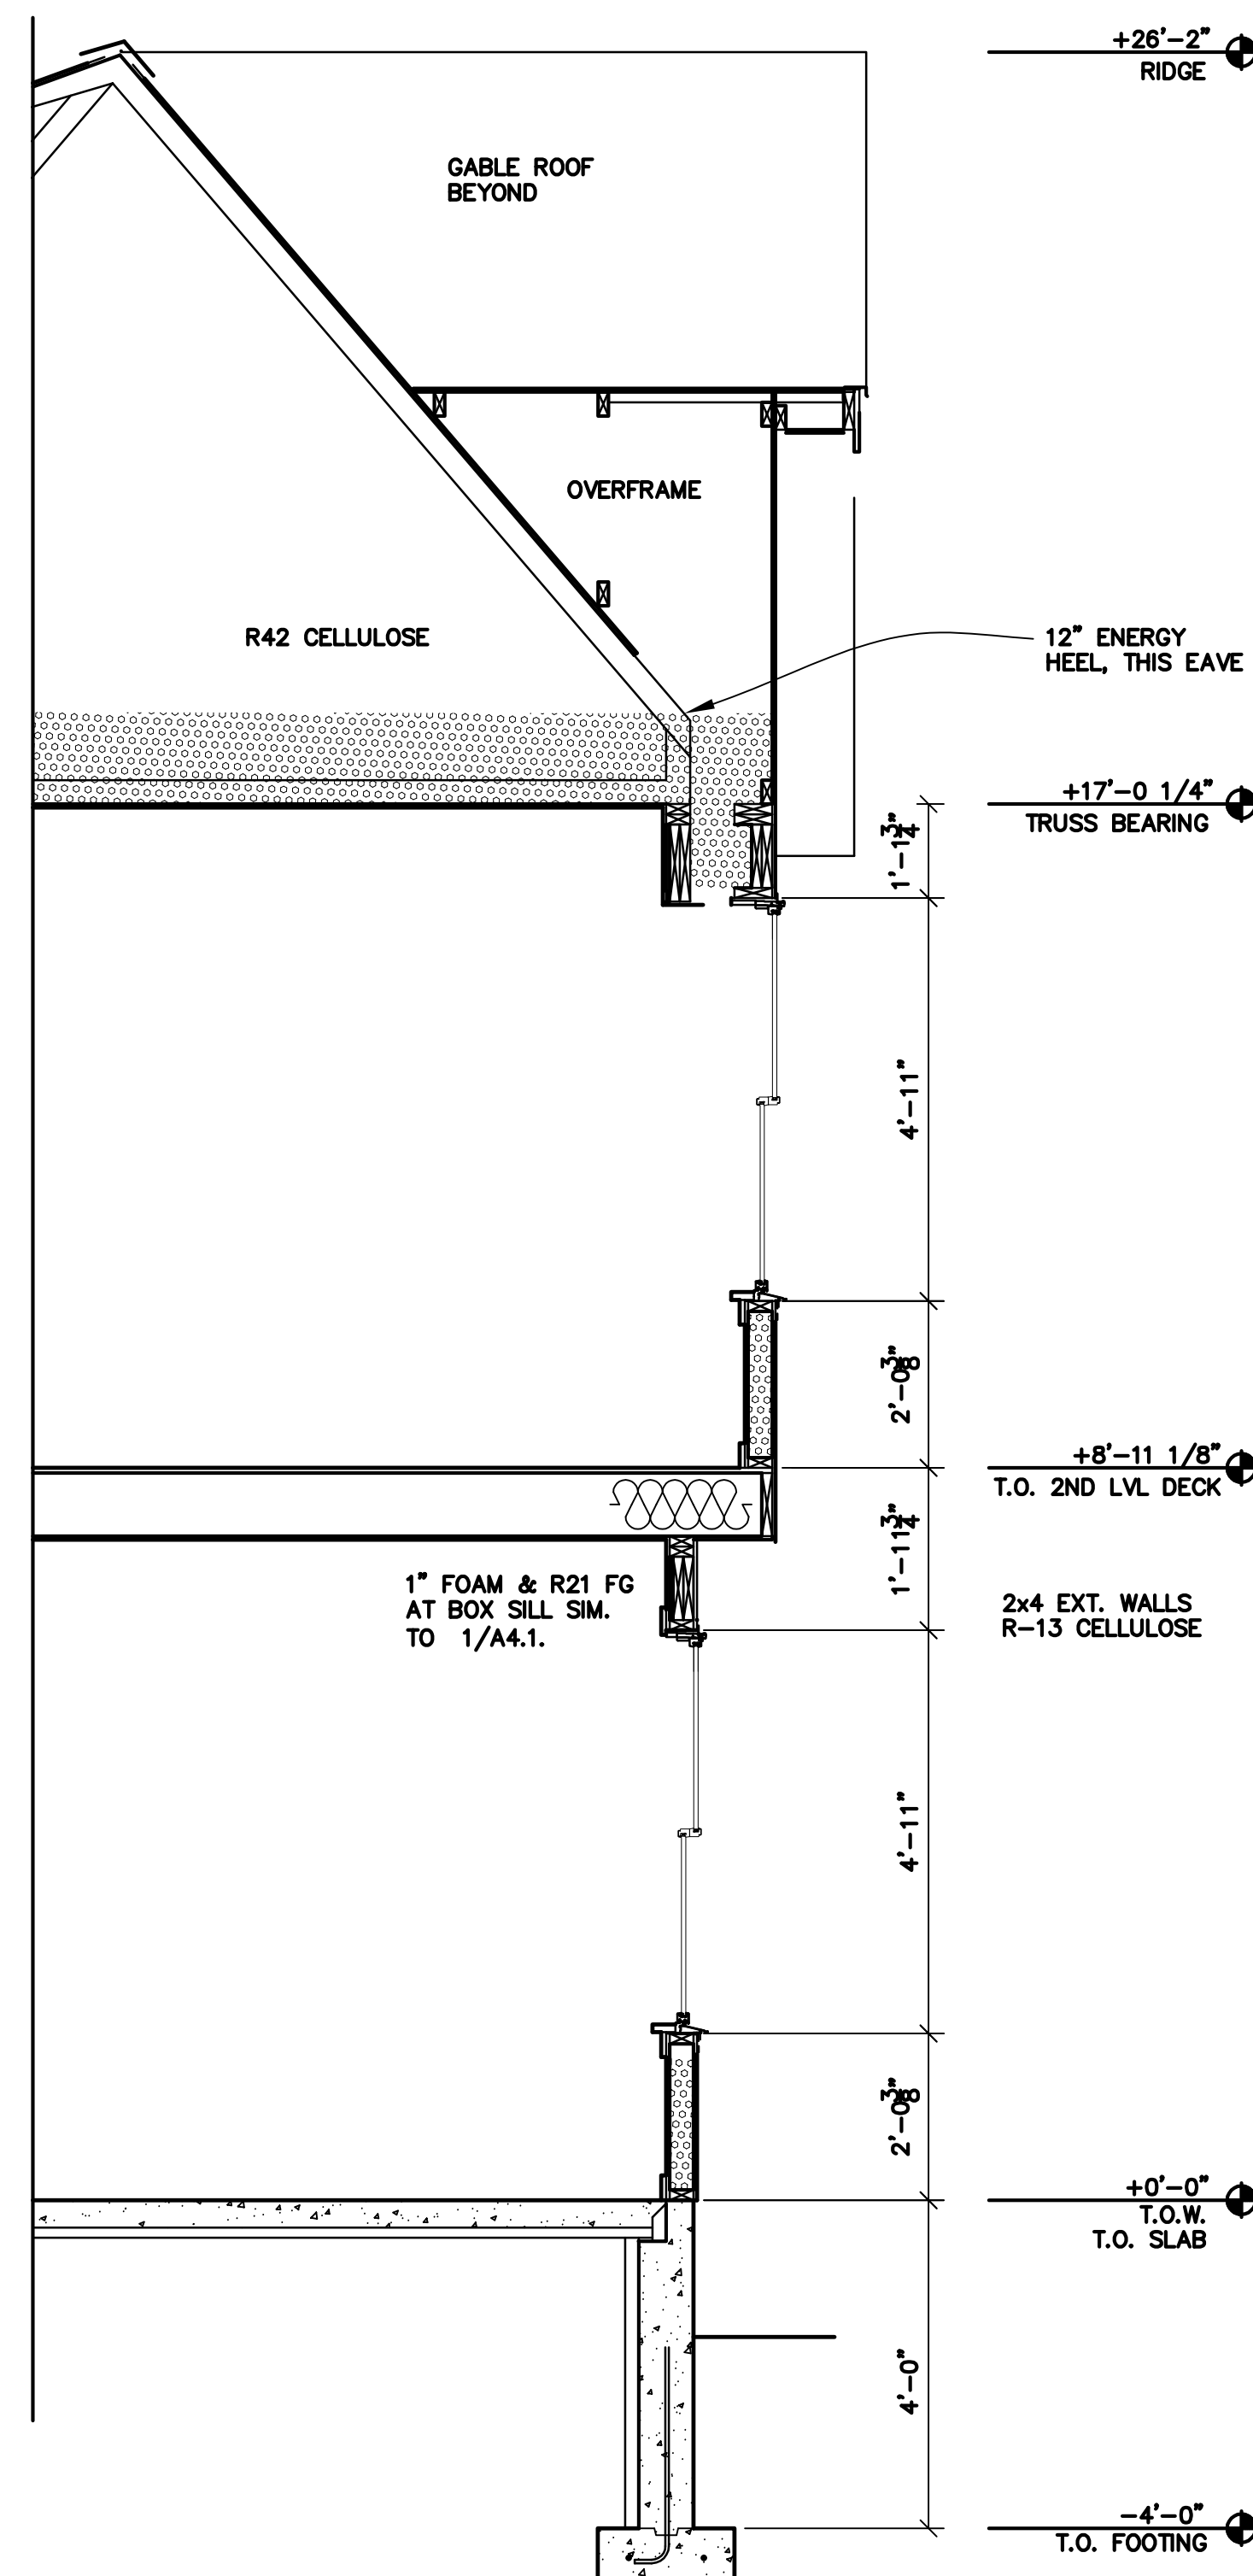

**NOT FOR CONSTRUCTION
FOR COORDINATION ONLY**
NO DRAWINGS DISPLAYING DATE OF ISSUANCE ON OR PRIOR TO
THAT SHOWN HERE ARE APPROVED FOR CONSTRUCTION.

VARIES
TOP OF ROOF DECK

+17'-0 1/4"
TOP OF WALL &
TRUSS BEARING

+8'-1 1/8"
TOP OF WALL

+0'-0"
TOP OF WALL

-4'-0"
TOP OF FTG

ALUM. SOFFIT DEPTH VARIES.
REFER TO 1/A2.2 ROOF FRM'G
FOR VENTING INFORMATION.

SLOPE PER
ROOF PLAN
9" HEEL AT
THIS EAVE

WINDOW WHERE
OCCURS

MIN. CLASS B ROOF COVERING.
ROOF DECK TO BE 1/2" FRT PLYWOOD 48"
MIN. FROM EACH SIDE OF FIRE WALL
(PER IBC 706.5 EXCEPTION 2)

ALUM FASCIA OVER 1x6
PER ELEVATIONS
OVER WRB

FASCIA & TRIM
PER ELEVATIONS
OVER WRB

1" CLOSED CELL FOAM +
R21 FG BATT AT BOX SILL, TYP.

5/8" TYPE-X GWB AT 1HR
WALL BOX JOIST WHERE
NOTED ON PLAN

5/8" TYPE-X GWB CONT.
BEHIND FLR JOIST AT
ALL FIRE RATED WALLS
PARALLEL TO JOISTS

+8'-11 1/8"
T.O. 2ND LVL FLR DECK

+8'-10 3/8"
T.O. PLATE AT FIREWALL

SIDING PER ELEV OVER
TYVEK WRB

5/8" OSB
(5/8" DENSGLASS AT 1HR)
5/8" GWB
(5/8" TYPE-X GWB AT 1 HR)

5/8" DENSGLASS
EACH SIDE
5/8" TYPE-X GWB
TOWARD DWELLING

5/8" DENSGLASS
5/8" TYPE-X GWB
ALUM. FLG.

1/2" OSB OVER
2x4 FRAMING

OVERHANG FNDN
BY 1/2"

SAW CUT 4" DEEP SLOT AT
CENTER OF THICKENED SLAB
PER PLAN

4" SOG W/ #8 MESH OVER
10 MIL VAPOR BARRIER OVER
3" HORIZ. ROCKWOOL
COMFORTBOARD 110 INSUL

3" VERT. ROCKWOOL
COMFORTBOARD 110
INSUL AT EXT. FNDN WALL.
CAREFULLY CUT 45° CHAMFER AT
TOP EDGE SO THAT SOG CAN
FINISH .5" FROM FACE OF FNDN
WALL

4'-0"

8"

1 HOUR FIRE BARRIER
WHERE INDICATED ON PLANS

1 WALL DETAIL
A4.1 SCALE: 1 1/2"=1'-0"

2 HOUR FIRE BARRIER

2 WALL DETAIL
A4.1 SCALE: 1 1/2"=1'-0"

1 HOUR FIRE BARRIER

3 WALL DETAIL
A4.1 SCALE: 1 1/2"=1'-0"

1 HOUR FIRE BARRIER

4 WALL DETAIL
A4.1 SCALE: 1 1/2"=1'-0"

NOT FOR CONSTRUCTION
FOR COORDINATION ONLY
NO DRAWINGS DISPLAYING DATE OF ISSUANCE OR PRIOR TO
THAT SHOWN HERE ARE APPROVED FOR CONSTRUCTION

South Bend Heritage

803 LINCOLN WAY WEST SOUTH BEND, IN 46616
PHONE (574) 289-1066 FAX (574) 289-4550

HOOSE COURT DUPLEX
227 S. SCOTT ST. & 703 W. WAYNE ST.
SOUTH BEND, IN 46601

REVISIONS


Bid
Set

Date: DEC. 17, 2020
Job Number:
Drafting: -
Approval: PDL


Wall
Details

Sheet Number:

A4.1

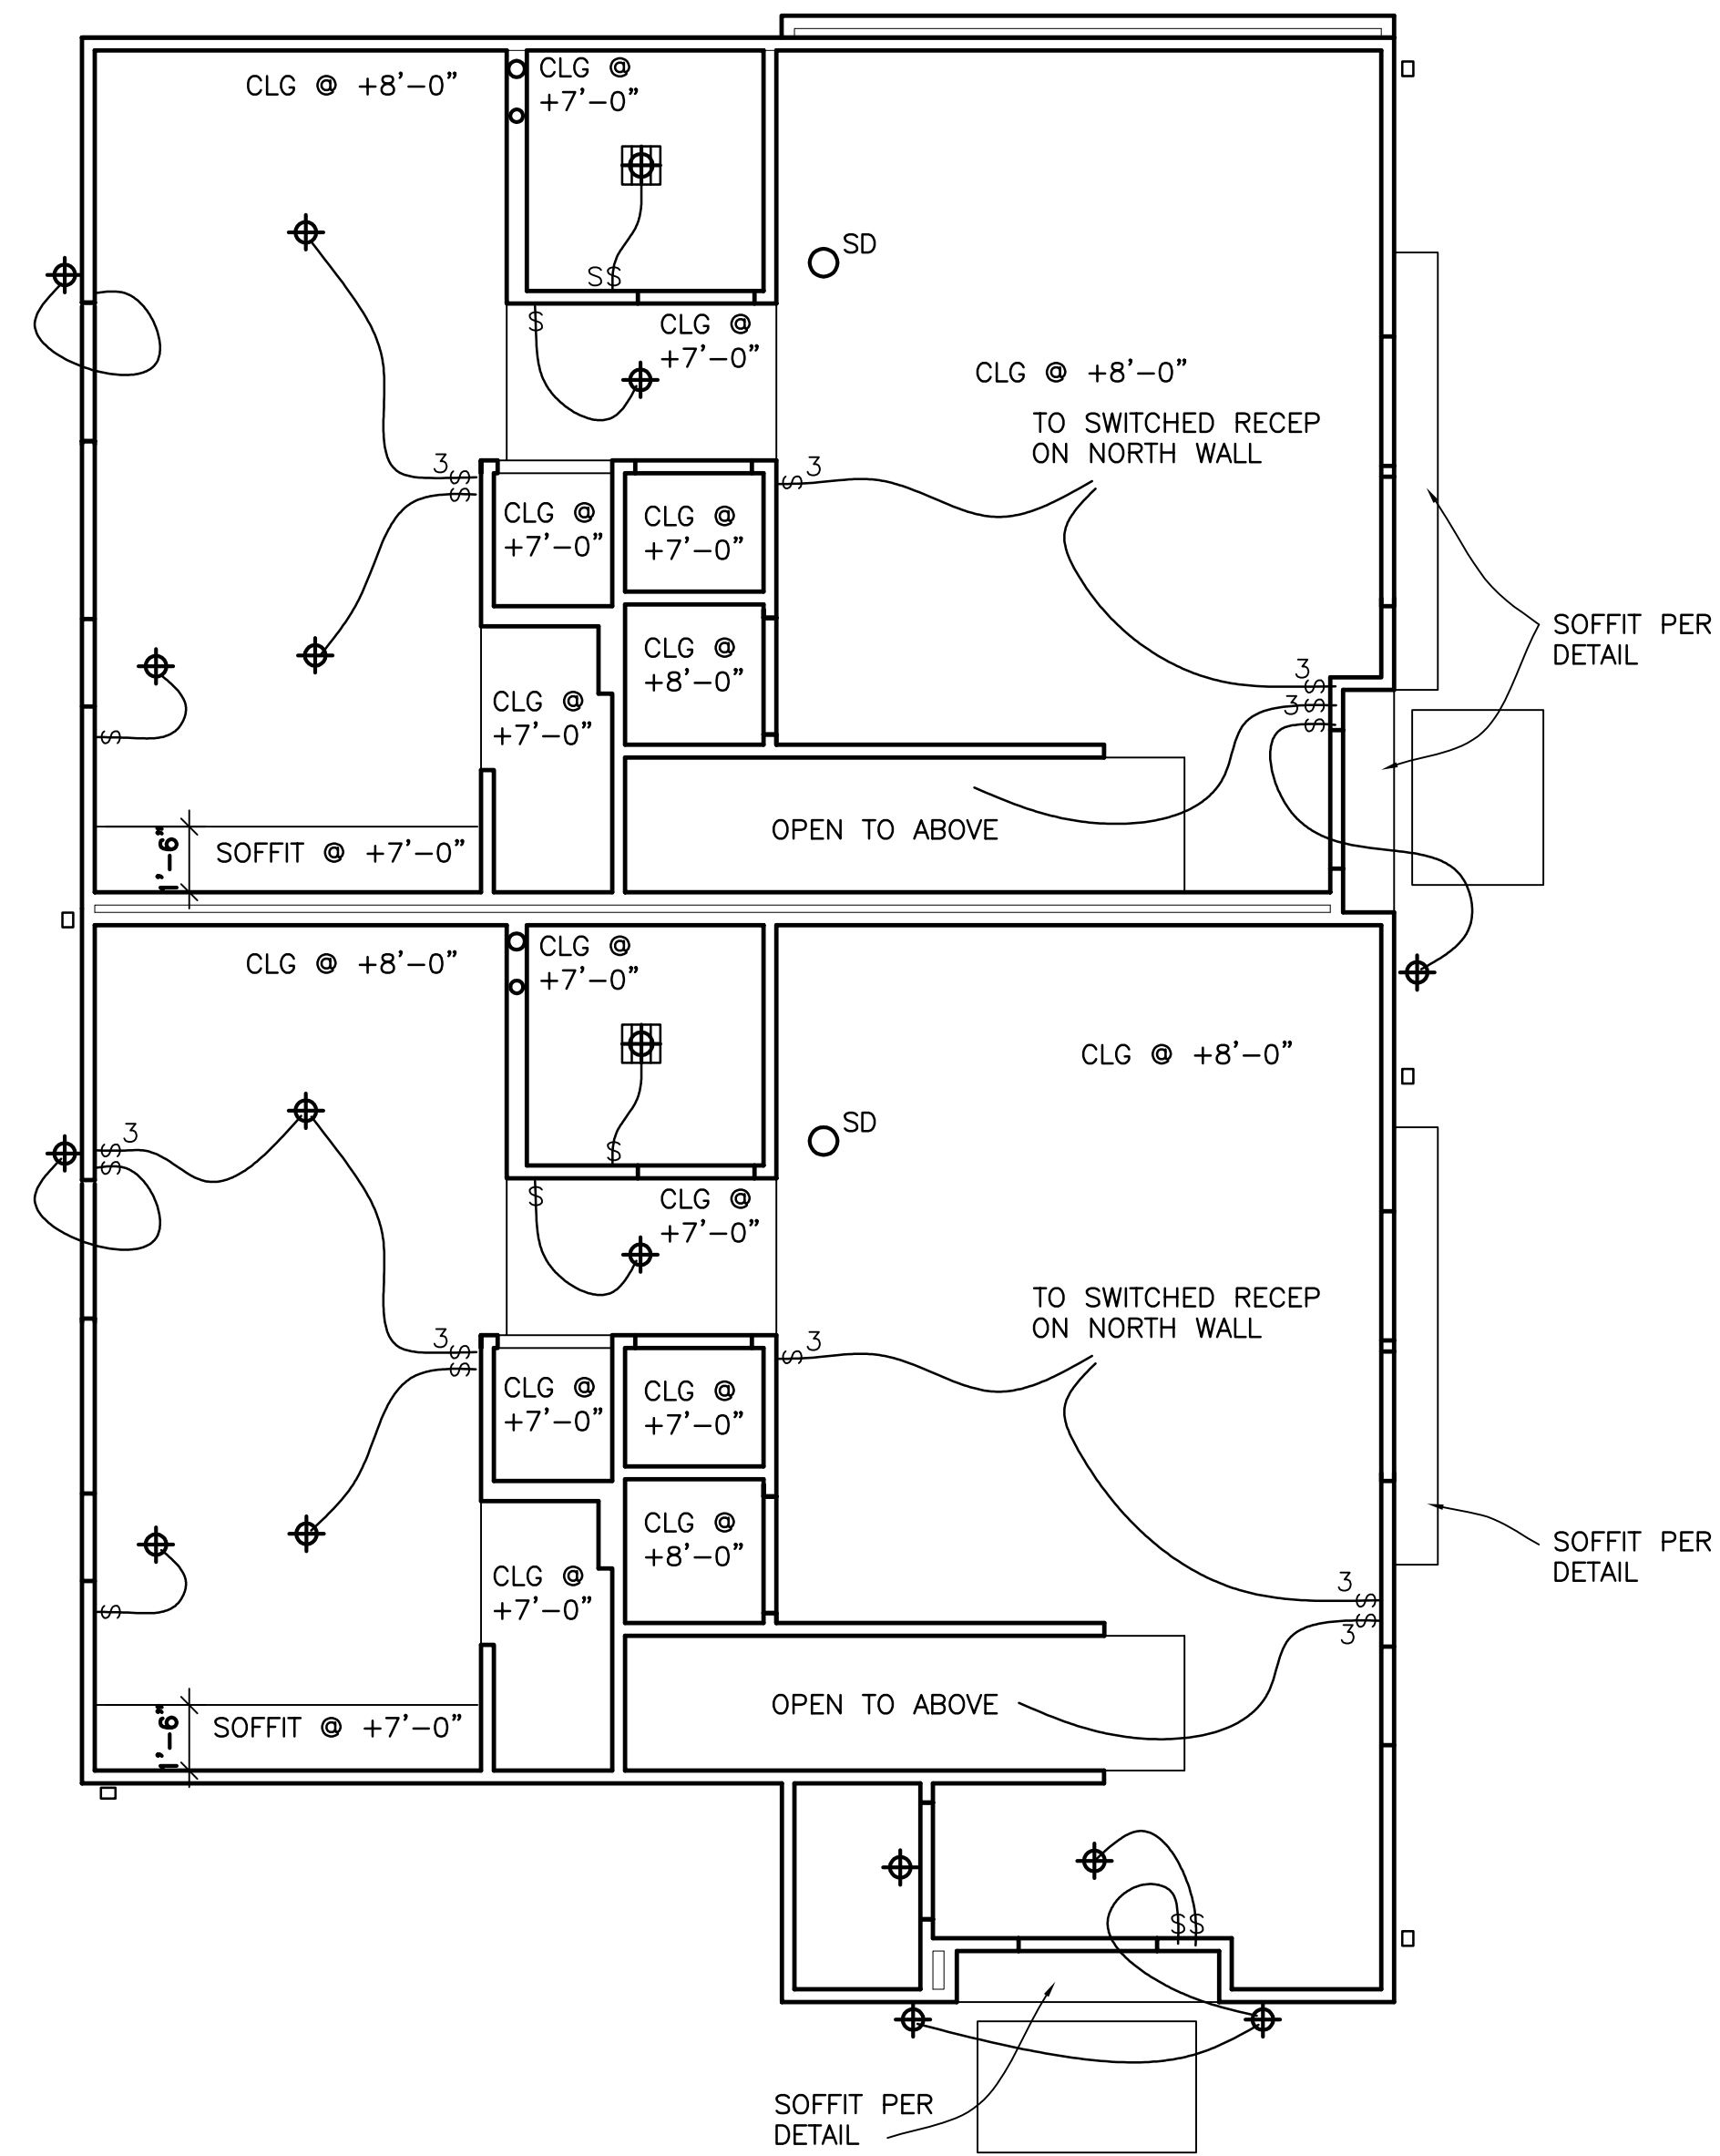


1 1ST FLOOR REFL CLG PLAN & LIGHTING
A6.0 SCALE: 1/4"=1'-0"

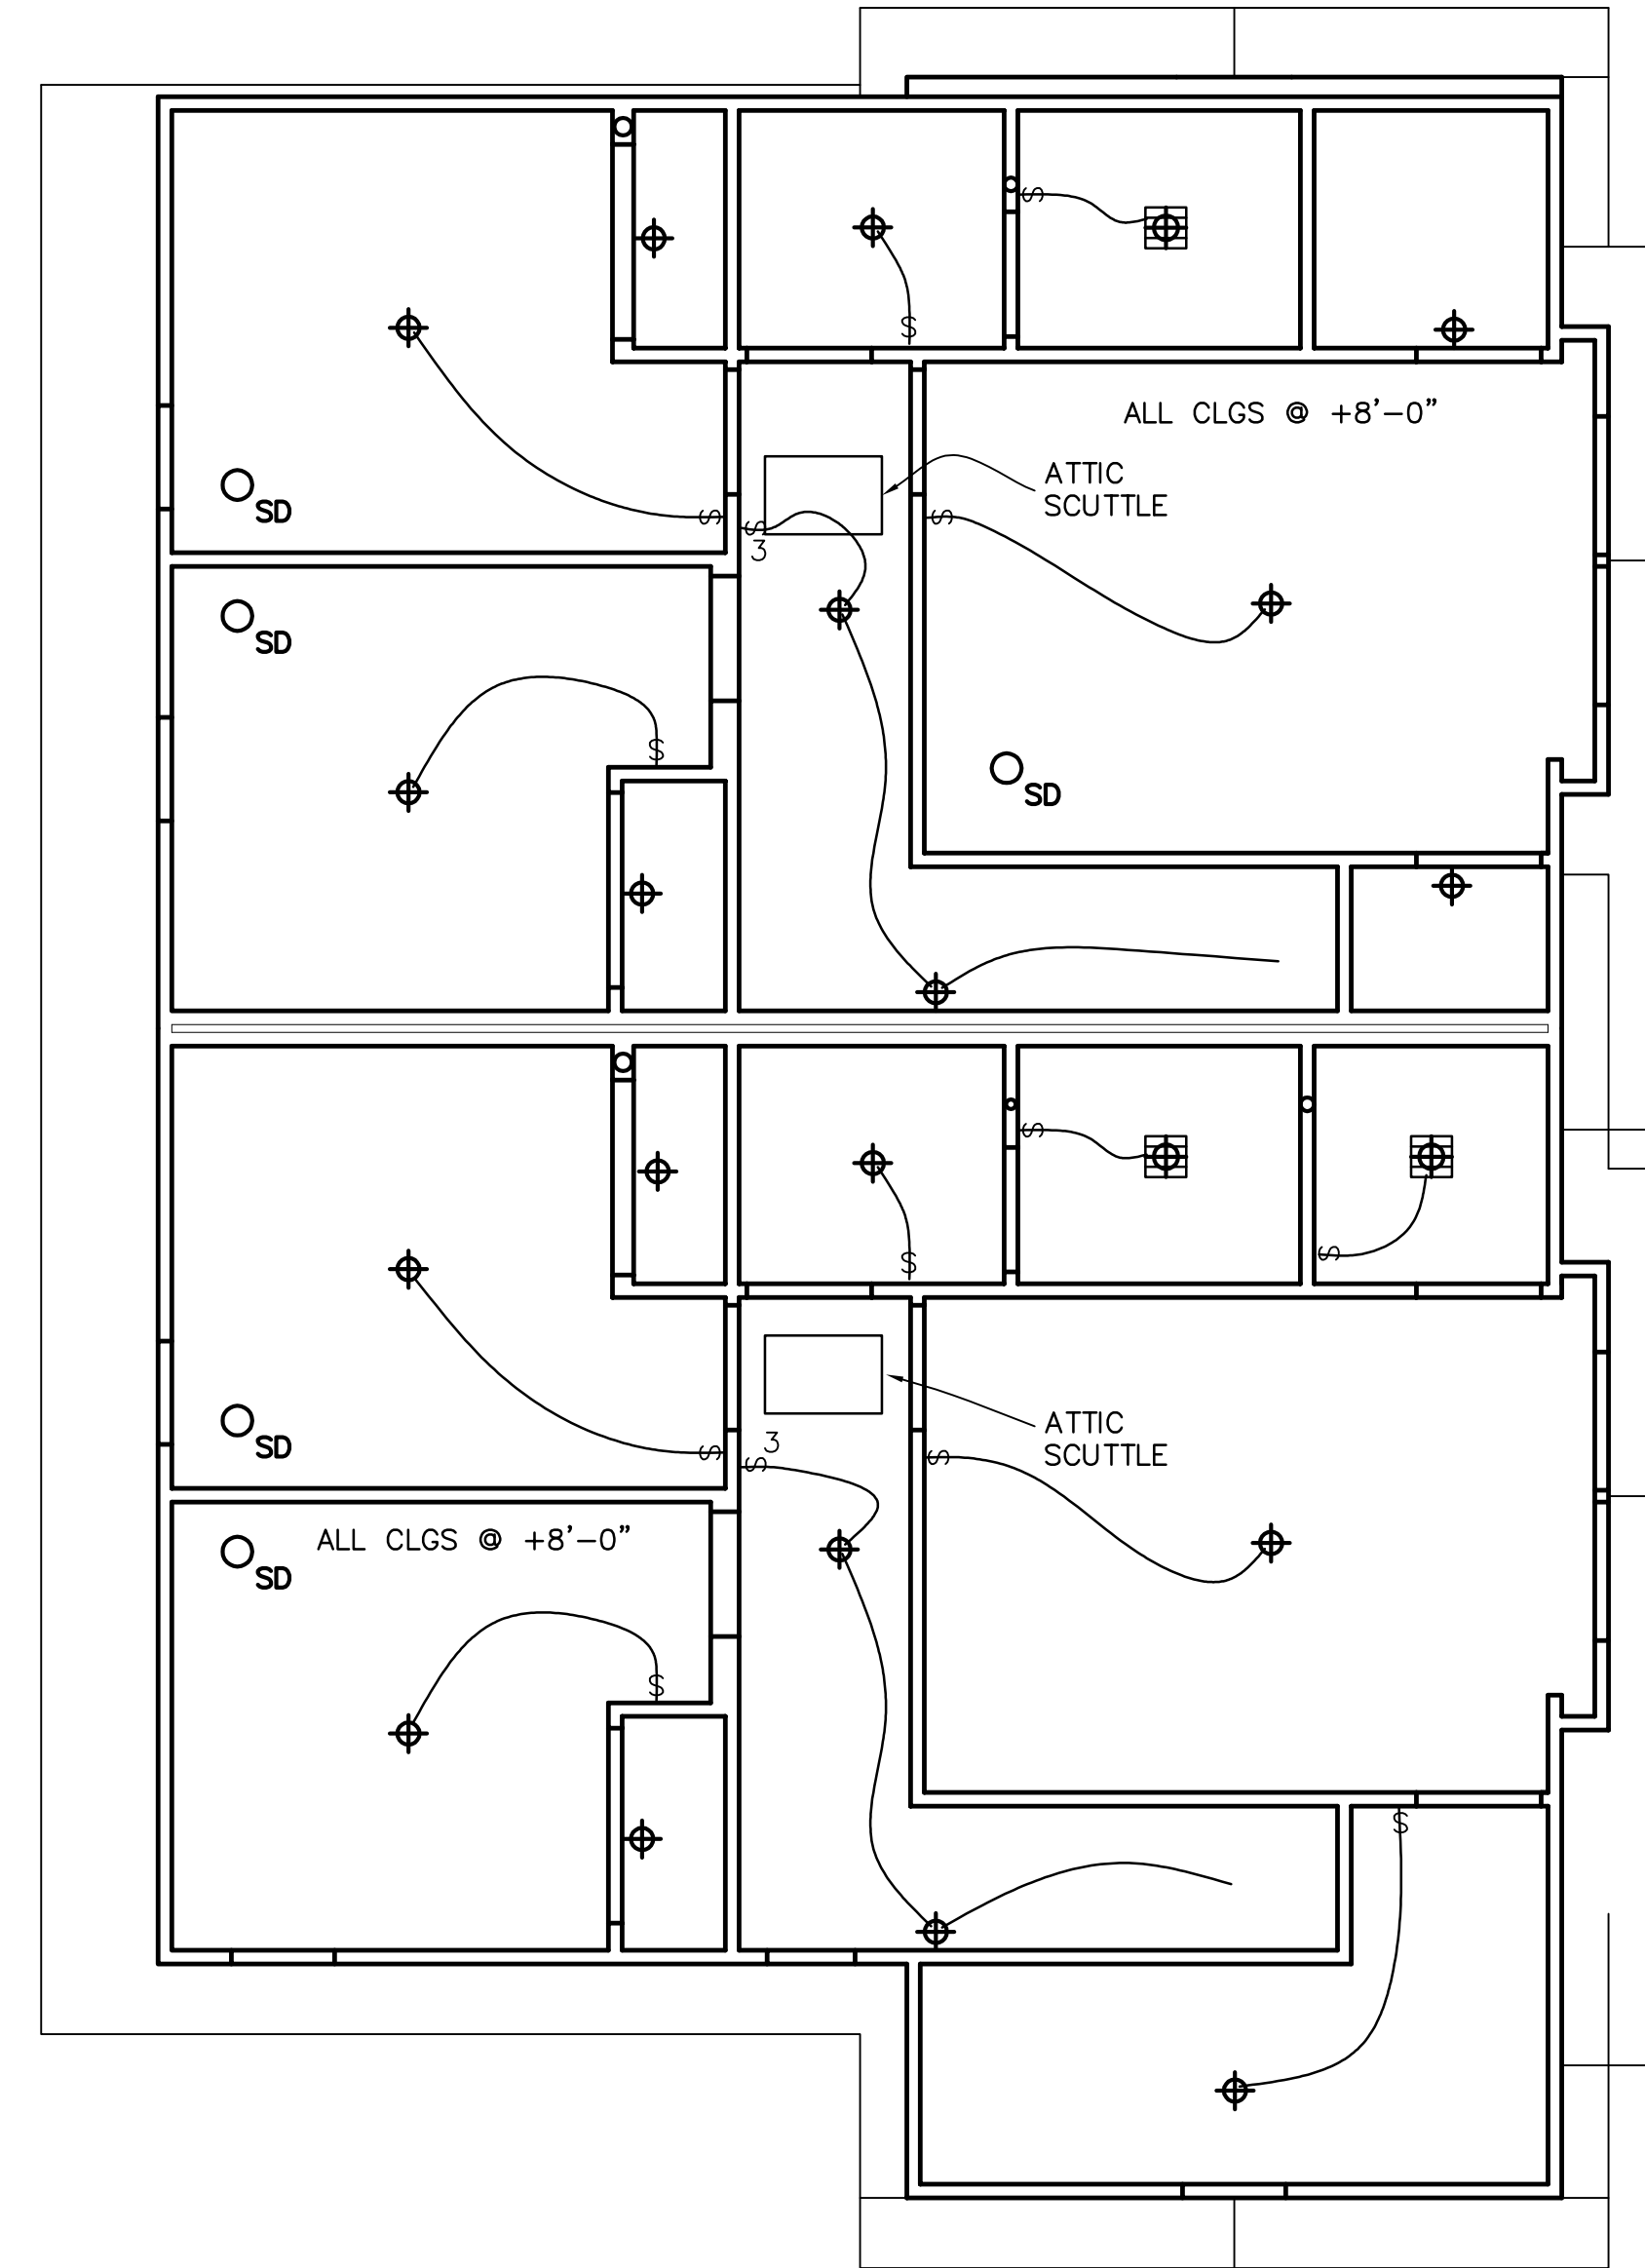


2 2ND FLOOR REFL CLG PLAN & LIGHTING
A6.0 SCALE: 1/4"=1'-0"


NOT FOR CONSTRUCTION
FOR COORDINATION ONLY
NO DRAWINGS DISPLAYING DATE OF ISSUANCE OR PRIOR TO
THAT SHOWN HERE ARE APPROVED FOR CONSTRUCTION

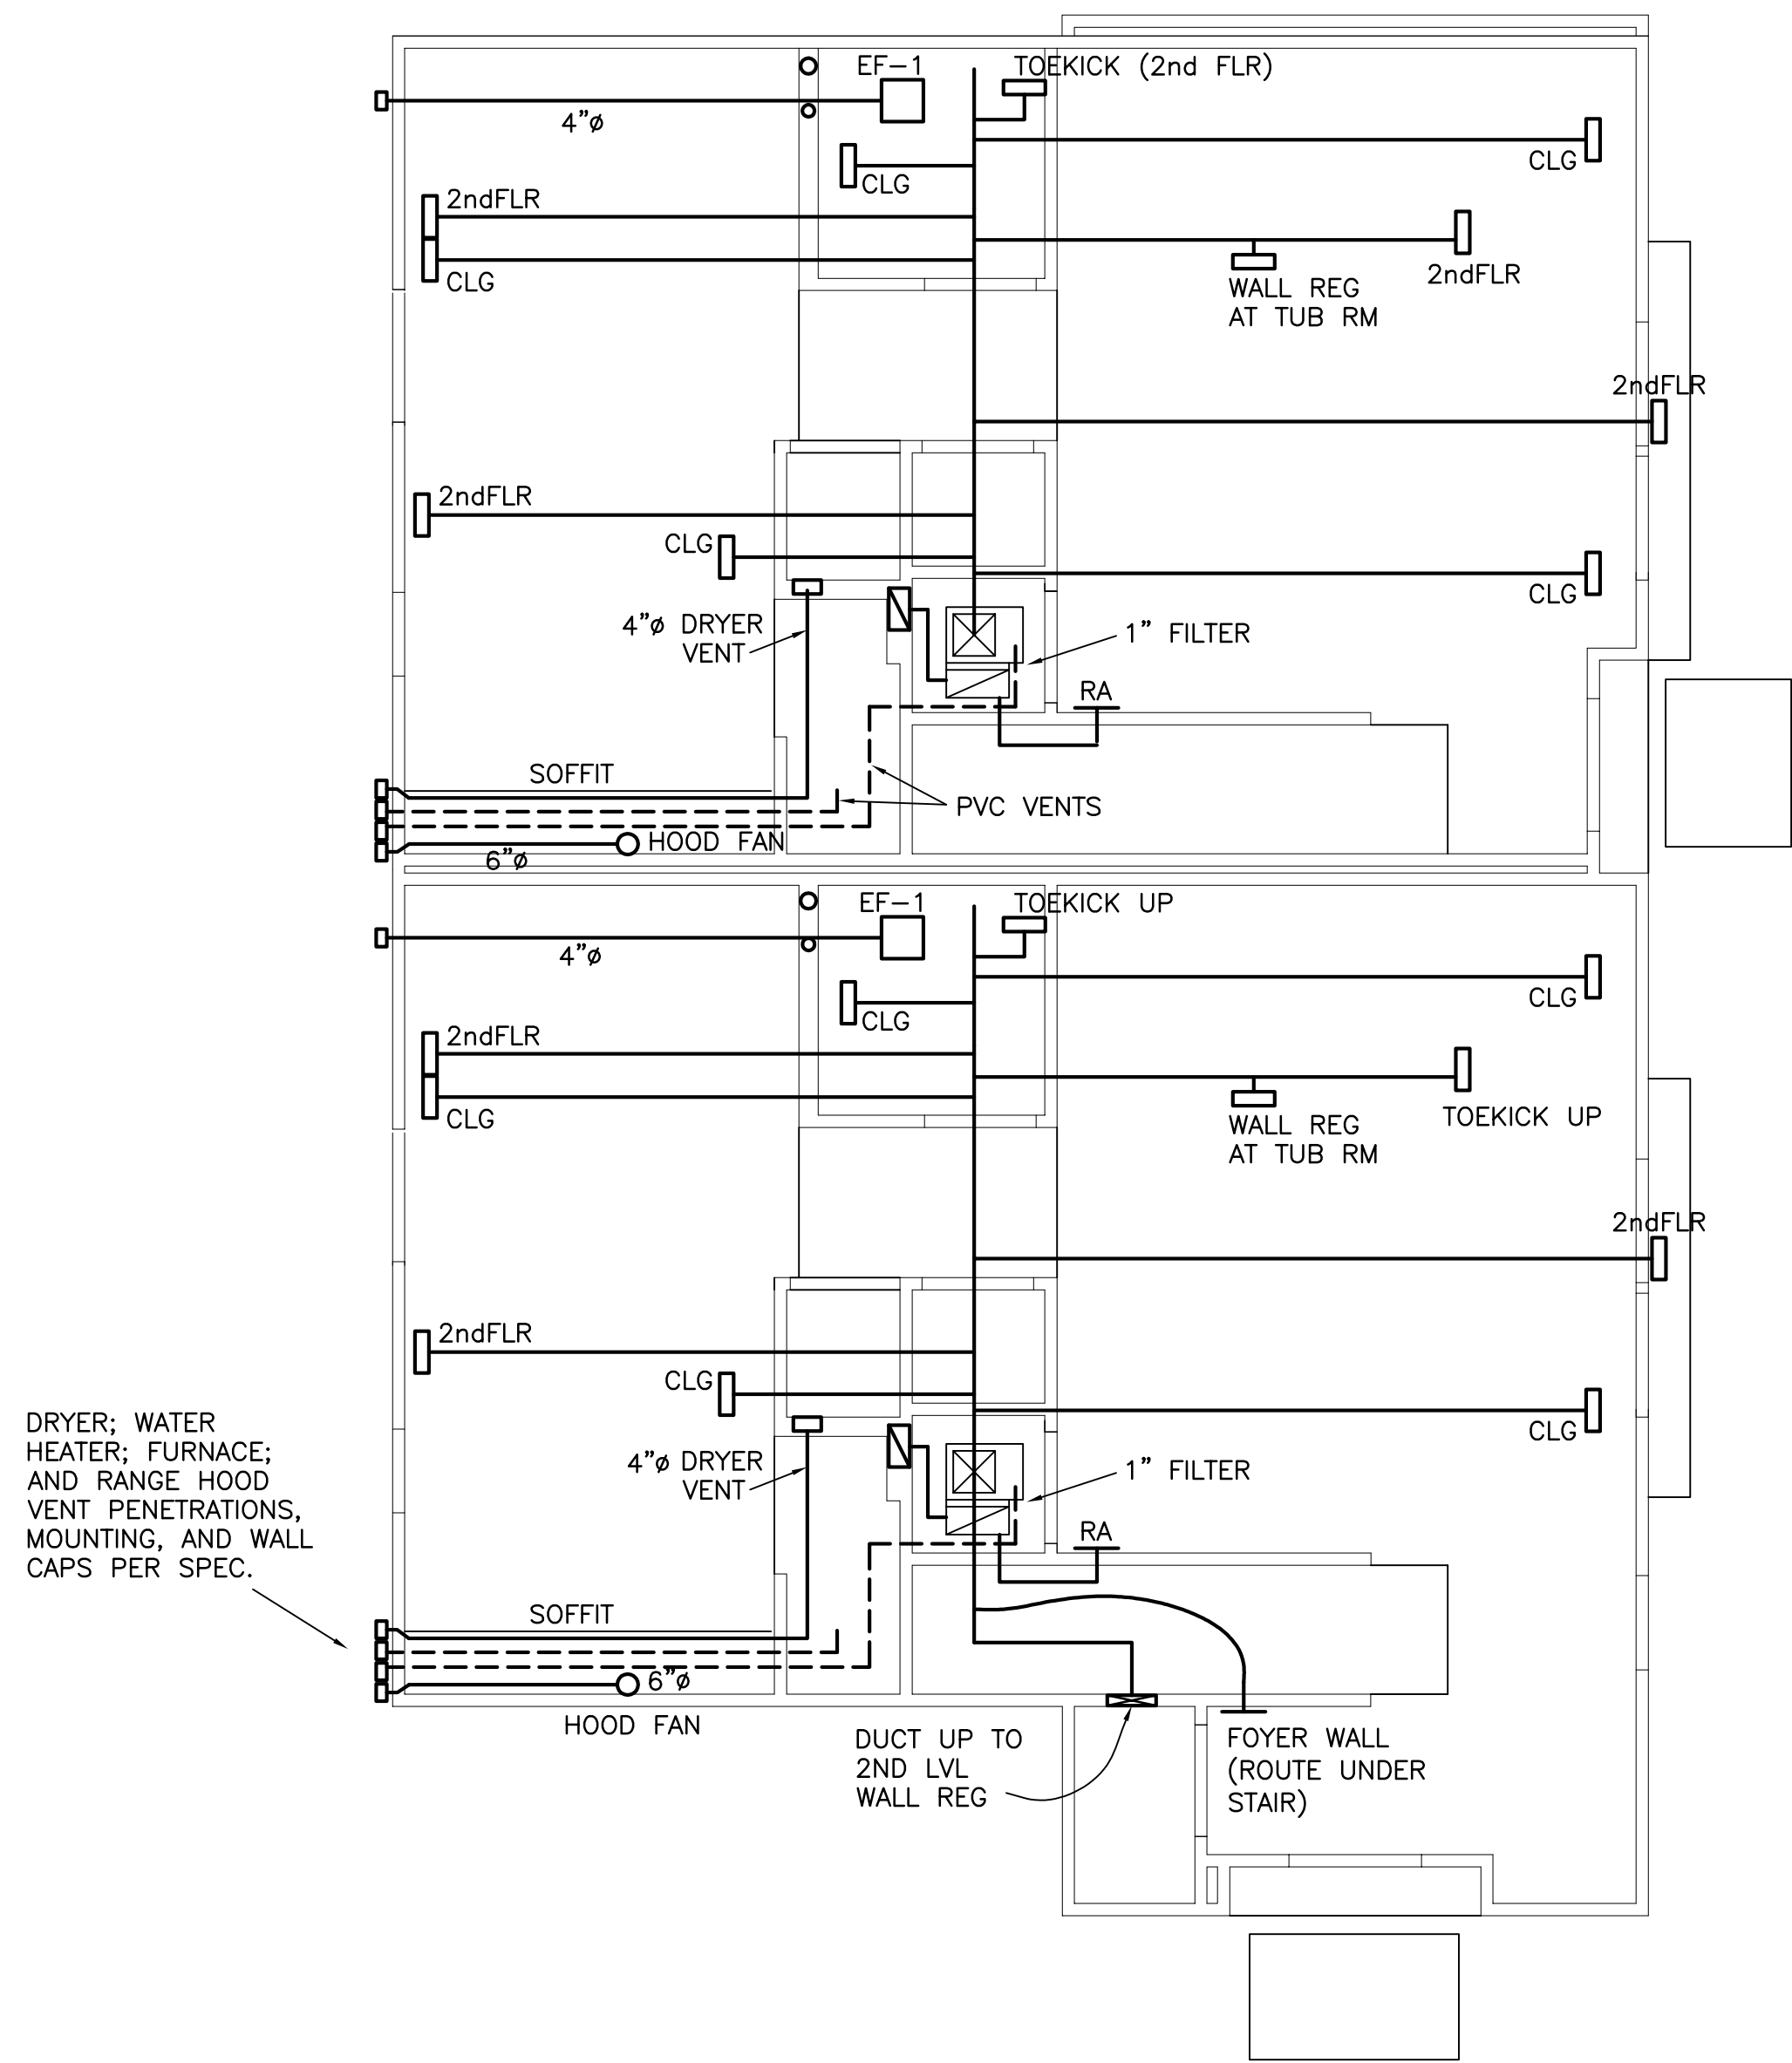


1 1ST FLOOR HVAC & VENTILATION
SCALE: 1/4"=1'-0"

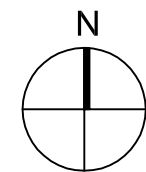

SYSTEM DESIGN AND DUCT
SIZING BY OTHER. THIS
HVAC LAYOUT IS SUGGESTED
PER FRAMING

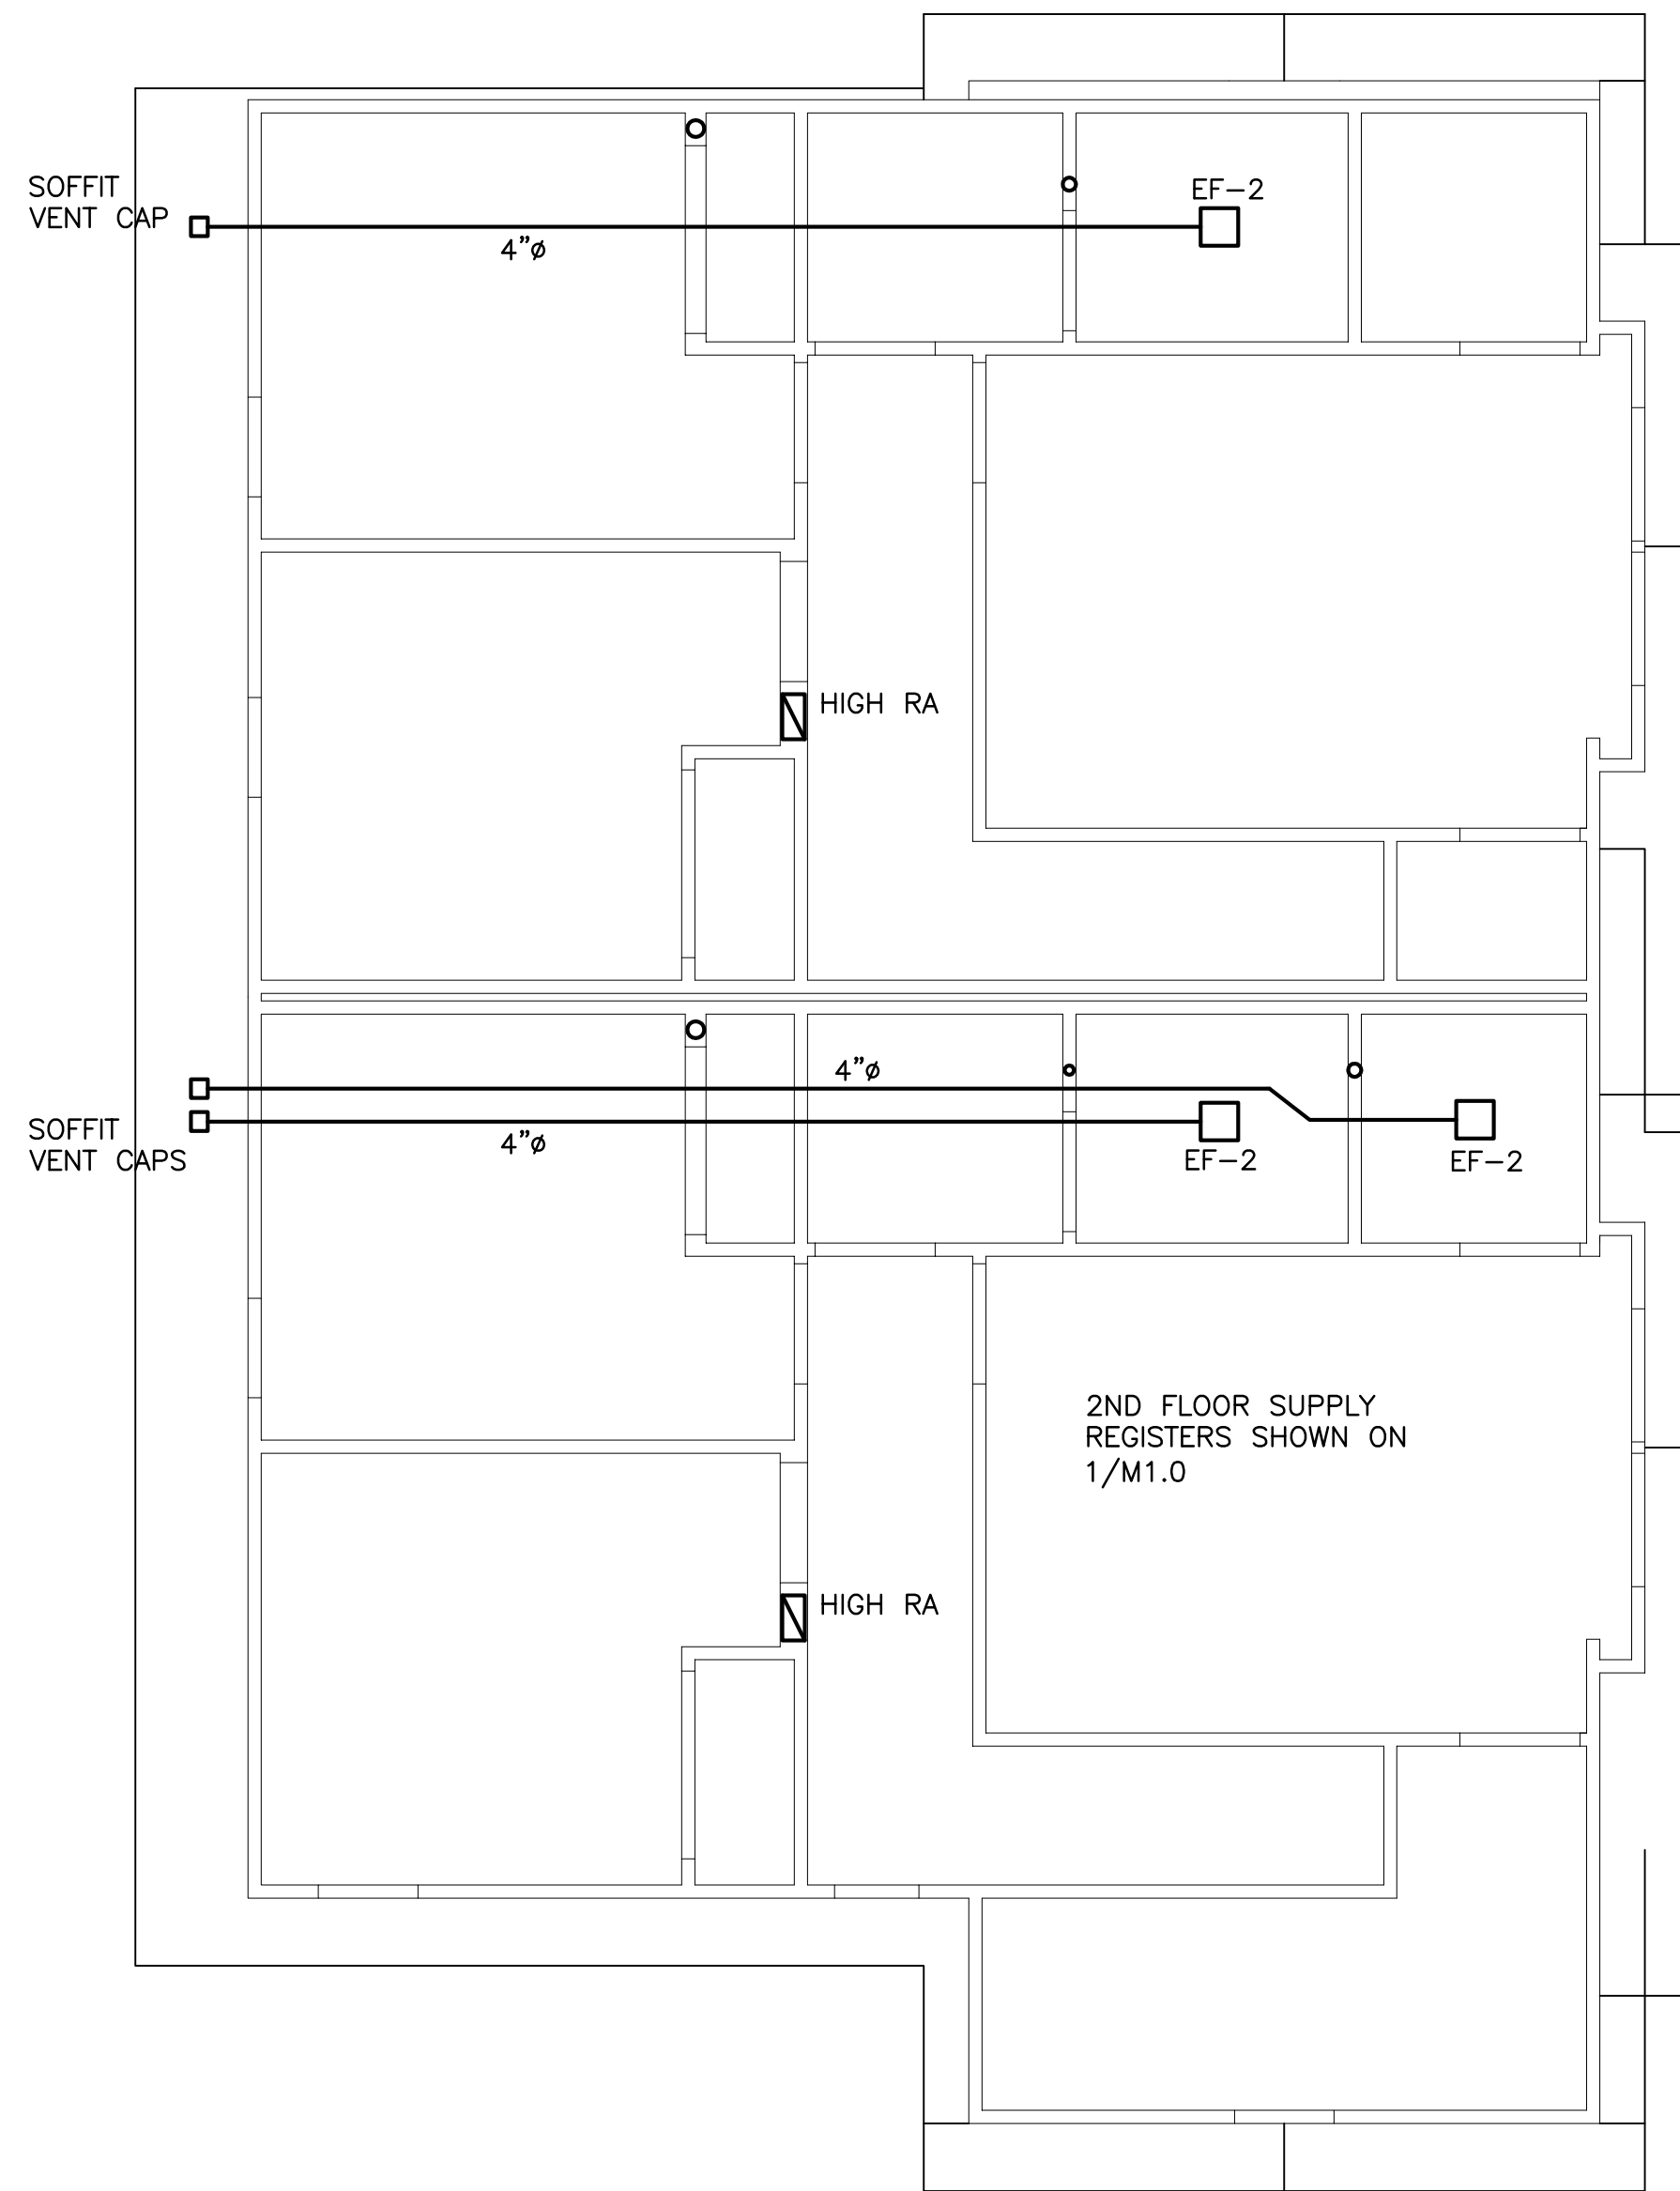

2 2ND FLOOR HVAC & VENTILATION
SCALE: 1/4"=1'-0"

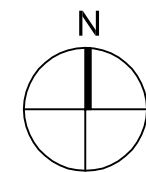

NOT FOR CONSTRUCTION
FOR COORDINATION ONLY
NO DRAWINGS DISPLAYING DATE OF ISSUANCE OR PRIOR TO
THAT SHOWN HERE ARE APPROVED FOR CONSTRUCTION

HOOSE COURT DUPLEX
227 S. SCOTT ST. & 703 W. WAYNE ST.
SOUTH BEND, IN 46601

South Bend Heritage
803 LINCOLN WAY WEST SOUTH BEND, IN 46616
PHONE (574) 289-1066 FAX (574) 289-4550

REVISIONS			

Bid Set	
Date:	DEC. 17, 2020
Job Number:	
Drafting:	-
Approval:	PDL

HVAC
Layout

Sheet Number:
M1.0